

PROJECT TITLE:

DUTCHESS COUNTY TEMPORARY HOMELESS SHELTER

PROJECT ADDRESS:

150 N. HAMILTON STREET POUGHKEEPSIE, NY 12601
RFB-DCB-01-24

CLIENT:

DUTCHESS COUNTY DEPARTMENT OF PUBLIC WORKS



SUE SERINO
DUTCHESS COUNTY EXECUTIVE

ROBERT H. BALKIND P.E.
DUTCHESS COUNTY DPW COMMISSIONER

CLIENT ADDRESS:

626 DUTCHESS TURNPIKE POUGHKEEPSIE, NY 12603

DRAWING INDEX

Sheet Number	Sheet Name
1 - GENERAL	
TS	TITLE SHEET
G-100	GENERAL NOTES & SPECIFICATIONS
G-101	PARTITION TYPES
2 - CIVIL	
C200	INTERIM SITE PLAN
C201	FINAL SITE PLAN
C300	SITE DETAILS
3 - ARCHITECTURAL	
A-101	FIRST FLOOR OVERALL PLAN - SELECTIVE DEMOLITION
A-102	SECOND FLOOR OVERALL PLAN - SELECTIVE DEMOLITION
A-103	THIRD FLOOR OVERALL PLAN - SELECTIVE DEMOLITION
A-104	FIRST FLOOR PLAN - NEW WORK
A-105	SECOND FLOOR PLAN - NEW WORK
A-106	THIRD FLOOR PLAN - NEW WORK
A-200	ENLARGED TOILET PLANS & DETAILS
A-201	ENLARGED KITCHEN PLAN
A-202	ENLARGED PLANS
A-203	PAINT DAMAGE REFERENCE PHOTOS
A-600	DOOR SCHEDULE & DETAILS
4 - MECHANICAL	
H000	MECHANICAL SYMBOLS LIST
H101A	FIRST FLOOR MECHANICAL DEMOLITION PLAN, NORTH
H101B	FIRST FLOOR MECHANICAL DEMOLITION PLAN, SOUTH
H102	SECOND FLOOR MECHANICAL DEMOLITION PLAN

Sheet Number	Sheet Name
H201A	FIRST FLOOR MECHANICAL NEW WORK PLAN, NORTH
H201B	FIRST FLOOR MECHANICAL NEW WORK PLAN, SOUTH
H202	SECOND FLOOR MECHANICAL NEW WORK PLAN
H203	ROOF MECHANICAL ROOM DEMOLITION AND NEW WORK PLANS
H800	MECHANICAL DETAILS, CONTROLS, AND SCHEDULES
5 - ELECTRICAL	
E000	ELECTRICAL SYMBOLS LEGEND AND NOTES
E101	ELECTRICAL DEMOLITION PLAN - FIRST FLOOR
E102	ELECTRICAL DEMOLITION PLAN - SECOND FLOOR
E103	ELECTRICAL DEMOLITION PLAN - THIRD FLOOR
E201	POWER AND SYSTEMS PLAN - FIRST FLOOR
E202	POWER AND SYSTEMS PLAN - SECOND FLOOR
E203	POWER AND SYSTEMS PLAN - THIRD FLOOR
E204	ELECTRICAL DEMOLITION AND NEW WORK PLANS - PENTHOUSE
E301	LIGHTING PLAN - FIRST FLOOR
E302	LIGHTING PLAN - SECOND FLOOR
E900	ELECTRICAL SCHEDULES AND PARTIAL ONE-LINE DIAGRAM
6 - PLUMBING	
P000	PLUMBING LEGEND, NOTES, & SCHEDULES
P001	PLUMBING OVERALL FIRST FLOOR PLAN
P002	PLUMBING OVERALL SECOND FLOOR PLAN
P003	PLUMBING OVERALL THIRD FLOOR PLAN
P101	PLUMBING FIRST FLOOR DEMOLITION PLANS
P201	PLUMBING FIRST FLOOR NEW WORK PLANS
P202	PLUMBING SECOND FLOOR NEW WORK PLANS

ISSUED FOR BID SET



DC TEMPORARY HOMELESS SHELTER
RFB-DCB-01-24
150 N HAMILTON STREET
POUGHKEEPSIE, NY 12601

SYMBOL LEGEND

DETAIL SECTION KEY:

1 - SECTION NUMBER
A101 - DRAWING NUMBER

Room name:

RM101 - ROOM NAME
101 - ROOM NUMBER

SECTION KEY:

1 - SECTION NUMBER
A101 - DRAWING NUMBER

EXTERIOR ELEVATION KEY:

1 - ELEVATION NUMBER
A-201 - DRAWING NUMBER

INTERIOR ELEVATION KEY:

1 - ELEVATION NUMBER
A-201 - DRAWING NUMBER

EXISTING TO REMAIN

EXISTING TO BE REMOVED

NEW WALL CONSTRUCTION

EXISTING DOOR

NEW DOOR

DOOR IDENTIFICATION NUMBER

NORTH ARROW


REVISION

WALL TYPE TAG


ABBREVIATIONS

A ACQUST. A.C.T.	ACOUSTICAL ACQUSTICAL CEILING TILE	K K.E.S.	KITCHEN EQUIPMENT SUPPLIER
B B.O. BLDG. BLKG. BRG.	BOTTOM OF BUILDING BLOCKING BEARING	L LAM. LAV. LBS. L.F. L.P.	LAMINATE LAVATORY POUNDS LINEAL FOOT LOW POINT
C CAB. CLG. C.J. C.L. C.C.S. C.L.R. C.M.U. CNTR. COL. CONC. CNSTR. CONT. CONTR. C.T.	CABINET CEILING CONTROL JOINT CENTER LINE CLOSET CLEAR CONCRETE MASONRY UNIT COUNTER COLUMN CONCRETE CONSTRUCTION CONTINUOUS CONTRACTOR CERAMIC TILE	M MANUF. MAX. MECH. MIN. MISC. M.O. MSRY. MTD. MTL.	MANUFACTURER MAXIMUM MECHANICAL MINIMUM MISCELLANEOUS MASONRY OPENING MOUNTED METAL
D DBL. DIA. DIM. DN. DR. DTL. DWG.	DOUBLE DIAMETER DIMENSION DOWN DOOR DETAIL DRAWING	N N.I.C. N.T.S.	NOT IN CONTRACT NOT TO SCALE
E EA. E.I.F.S. ELEC. ELEV. EQ. EQUIP. ETC. EXIST. EXT.	EACH EXTERIOR INSULATION FINISH SYSTEM ELECTROELECTRICAL ELEVATION EQUAL EQUIPMENT ET CETERA EXISTING EXTERIOR	O O.C. O.D. O.H. OPNG. OPP. OPT.	ON CENTER OUTSIDE DIAMETER OPPOSITE HAND OPENING OPPOSITE OPTIONAL
F F.D. FON. F.E. FIN. FIXT. FLR. F.R.P. FT. FTG.	FLOOR DRAIN FOUNDATION FIRE EXTINGUISHER FINISH FIXTURE FLOOR FIBERGLASS REINF. PLASTIC FEET/FOOT FOOTING	P PL. PLUMB. PLYWD. PNL. PR. PREP. PT.	PLATE PLUMBING PLYWOOD PANEL PAIR PREPARATION/PREPARED PART/POINT
G GA. GALV. G.C. GL. GYP.	GAGE/GUAGE GALVANIZED GENERAL CONTRACTOR GLASS GYPSUM	R R.A. RAD. RCPT. REINF. REQD. R.O. R.T.U.	RETURN AIR RADIUS RECEPTACLE REINFORCING REQUIRED ROUGH OPENING ROOF TOP UNIT
H H.C. H.C. HDR. H.M. H.P. H.R.C. HT. H.V.A.C.	HANDICAP ACCESSIBLE HOLLOW CORE HEADER HOLLOW METAL HIGH POINT HEATING & REFRIGERATION CONTRACTOR(S) HEIGHT HEATING, VENTILATION, AIR CONDITIONING	S S.C. SCHD. SF. SHI. SIM. SPECS. SPRINK. SQ. S.S. STD. STL. STRUCT. SUSP.	SOLID CORE SCHEDULE STOREFRONT SHEET SIMILAR SPECIFICATIONS SPRINKLERS SQUARE STAINLESS STEEL STANDARD STEEL STRUCTURAL/STRUCTURE SUSPENDED
I IN. INFO. INT. INSUL.	INCHES INFORMATION INTERIOR INSULATION	T T.O. T&B T&G TEMP. TYP.	TOP OF TOP & BOTTOM TONGUE & GROOVE TEMPERED TYPICAL
J J-BOX JST.	JUNCTION BOX JOIST	V V. V.C.T. VERT.	VOLT/VOLTAGE VINYL COMPOSITION TILE VERTICAL
		W W/ W/O W.B. W.C. W.D. W.H. WDW. WT. W.W.F.	WITH WITHOUT WALL BASE WATER CLOSET WOOD WATER HEATER WINDOW WEIGHT WELDED WIRE FABRIC


LOCATION MAP

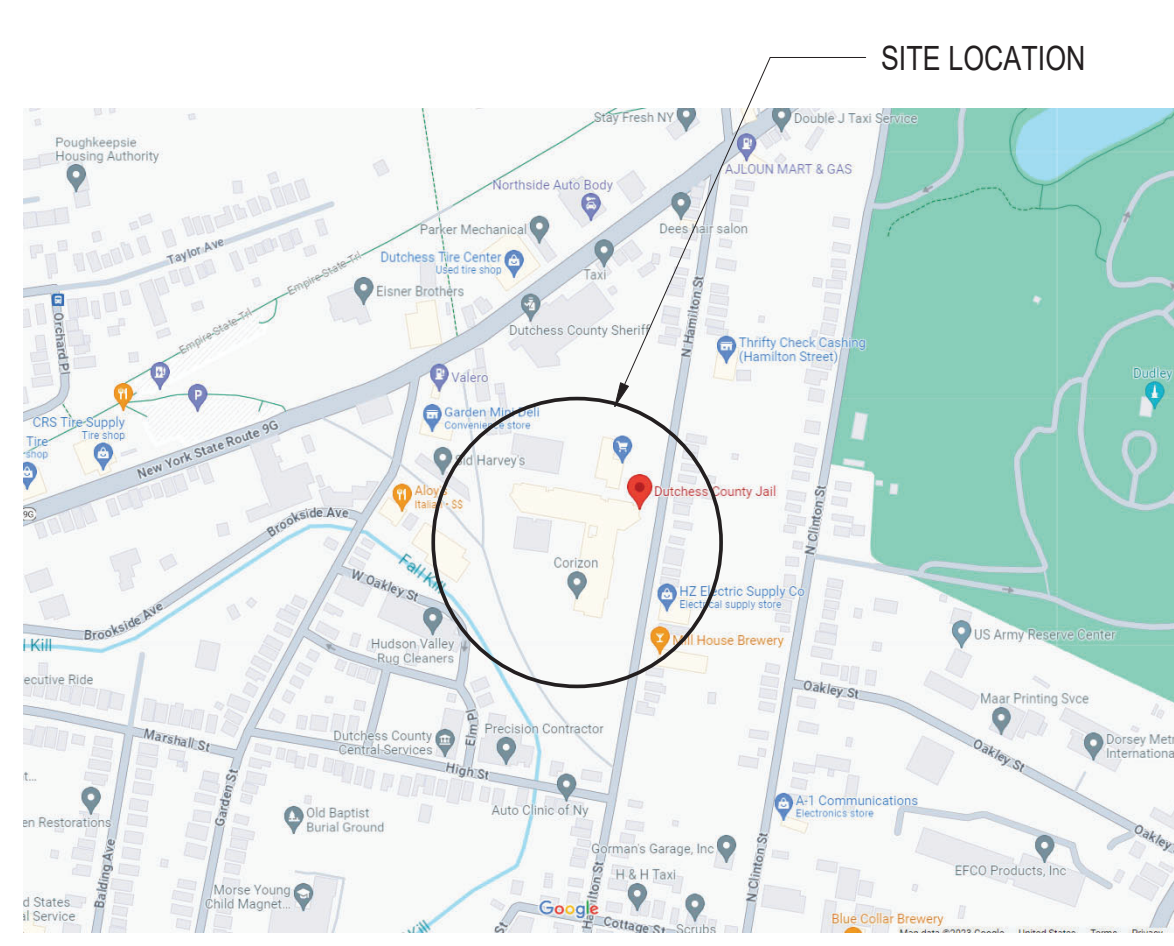

NEIGHBORHOOD MAP

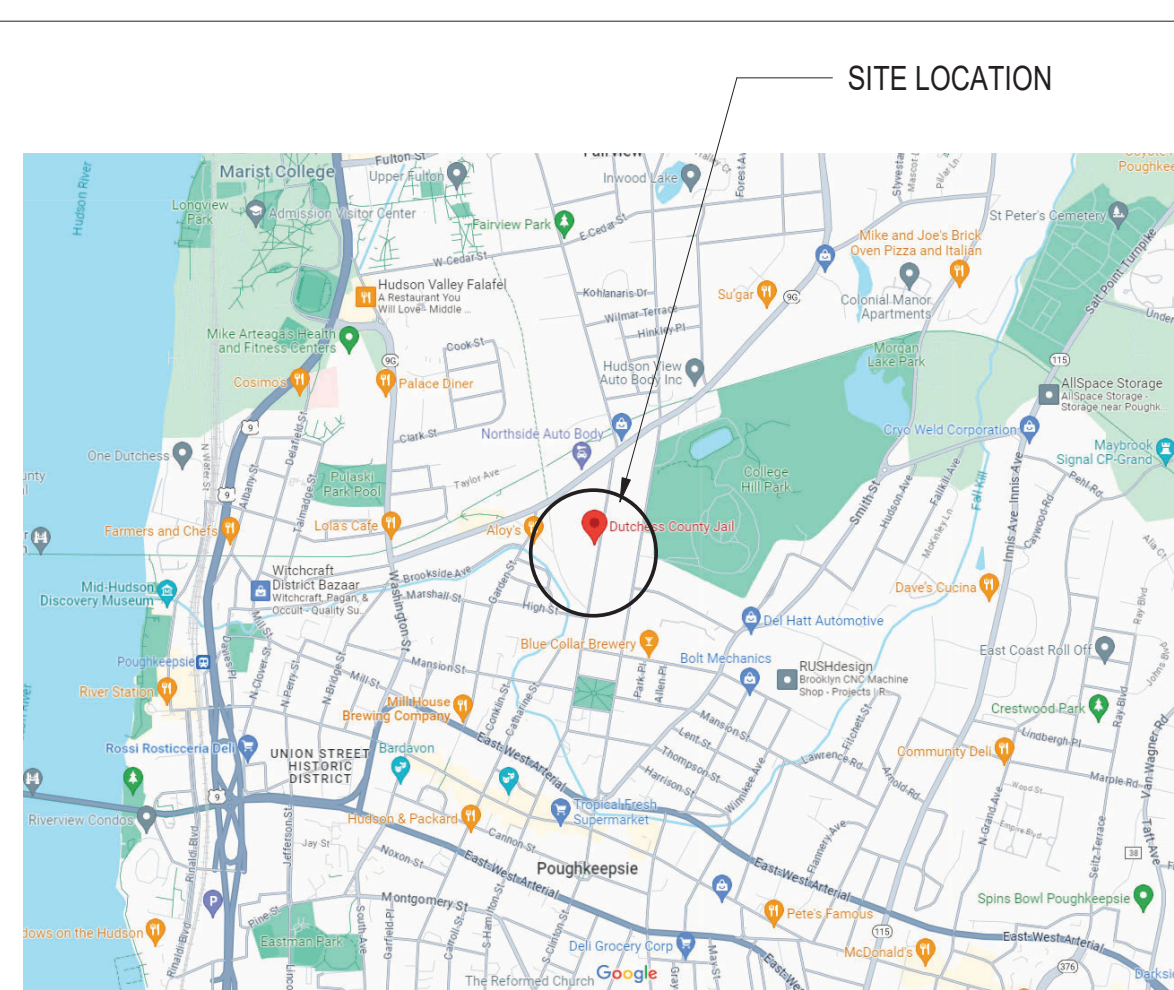

KEY PLAN

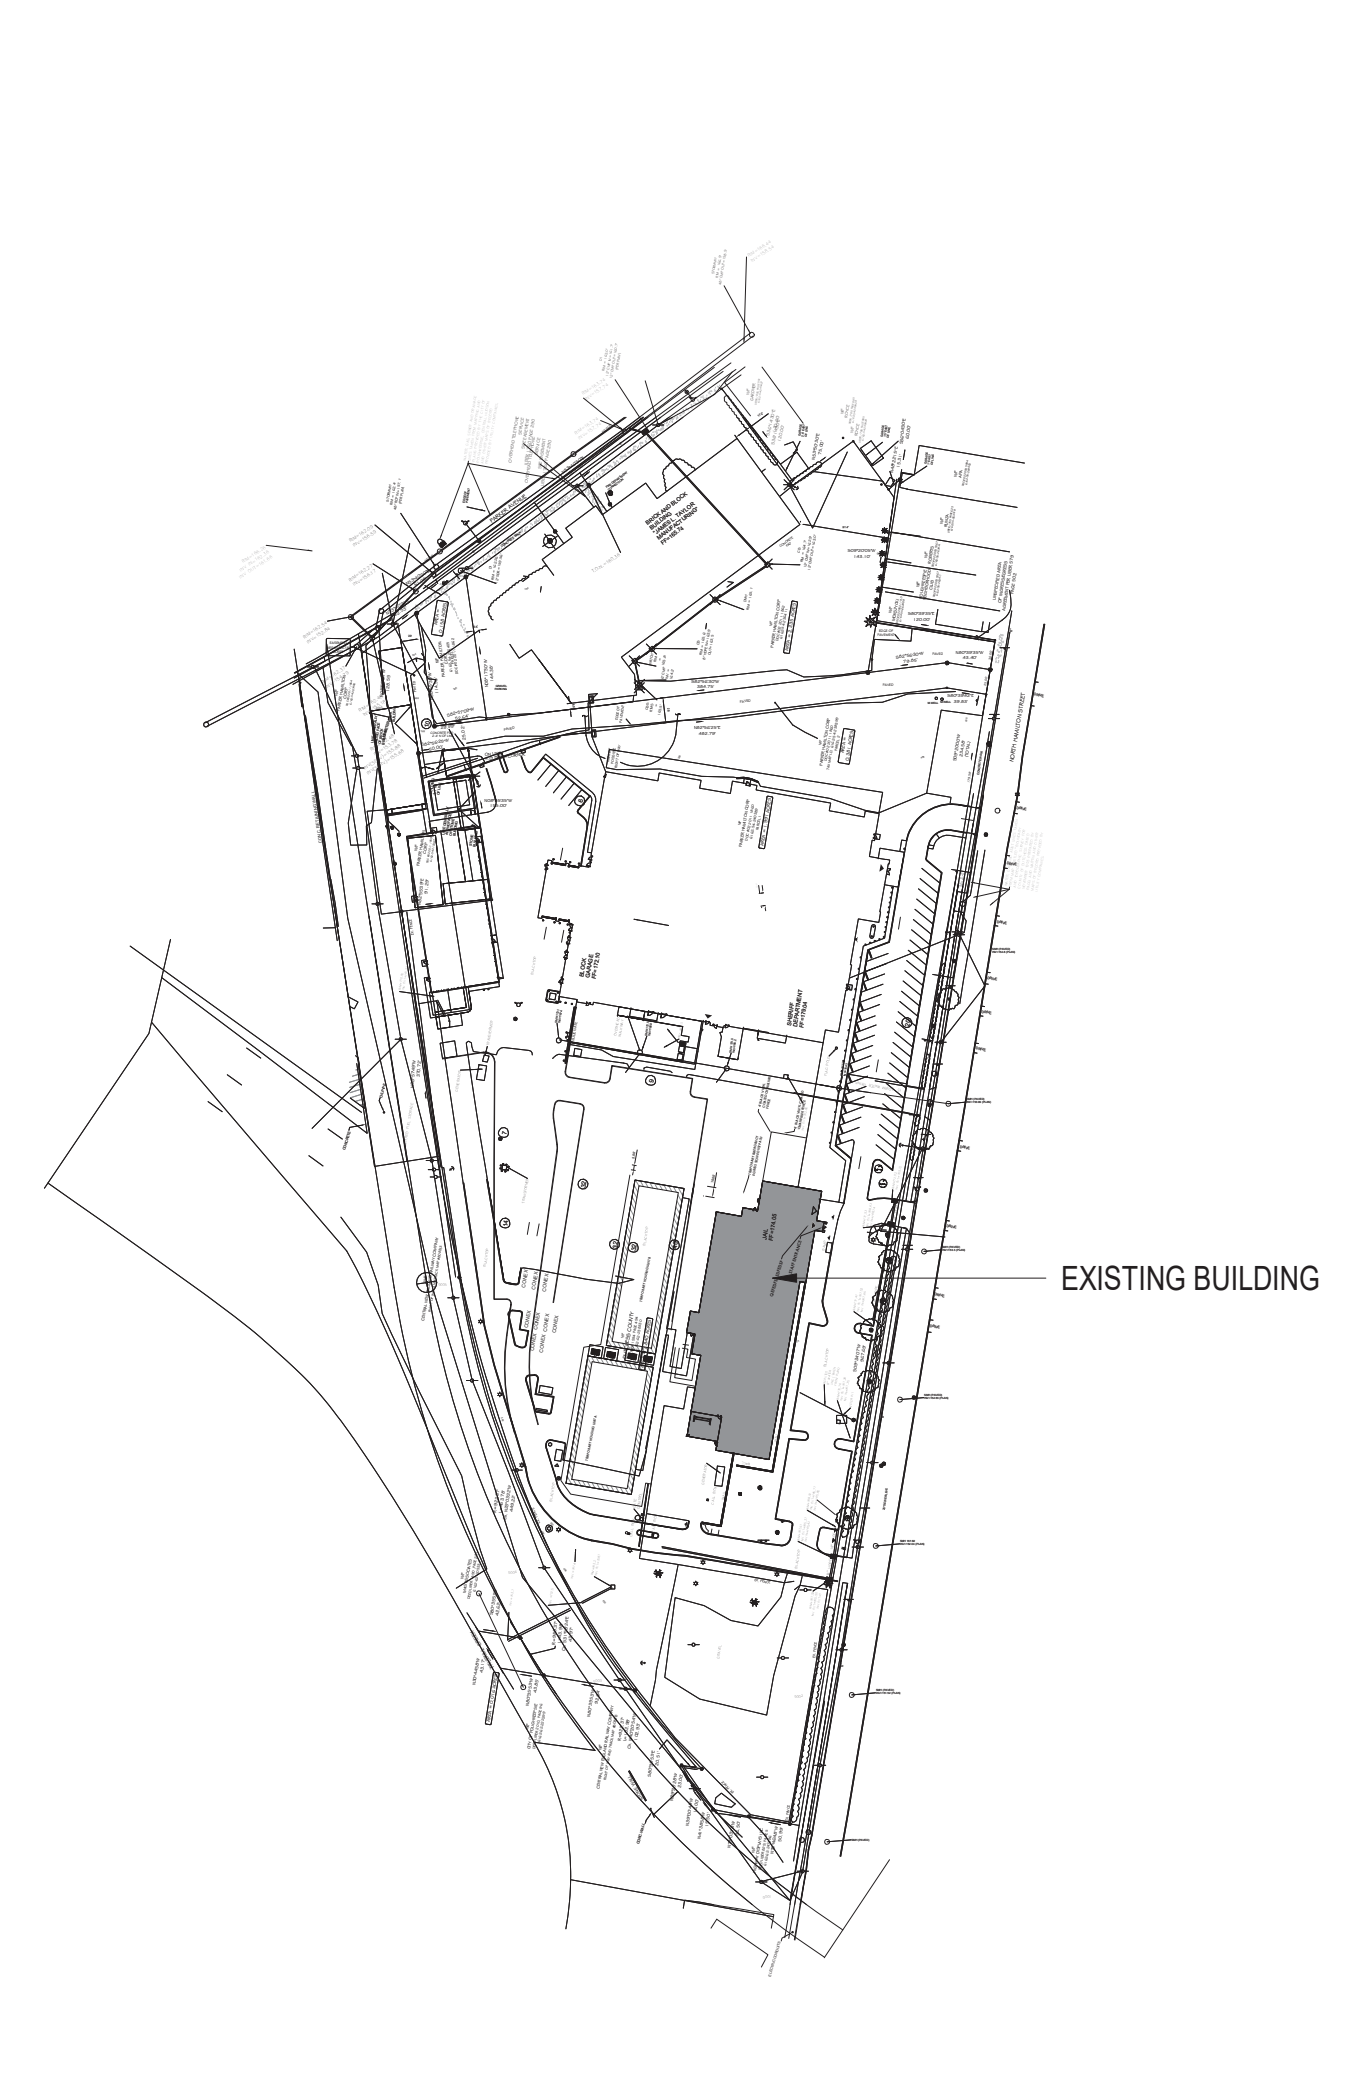

MATERIAL LEGEND

BATT INSULATION

CONCRETE MASONRY UNIT

CONCRETE

EARTH

FINISH WOOD

FIRE-PROOFING

GRAVEL FILL

GYPSUM WALL BOARD

PLYWOOD

RIGID INSULATION

ROUGH WOOD BLOCKING

SHIM

STEEL

No.	Description	Date
1	ISSUED FOR BID	01/18/2024

TINKELMAN ARCHITECTURE PLLC | 2023
ALL RIGHTS RESERVED. COPY OR REPRODUCTION OF THIS DRAWING OR ANY PORTION THEREOF IS PROHIBITED WITHOUT THE WRITTEN PERMISSION OF THE ARCHITECT. UNAUTHORIZED ALTERATION OR ADDITION TO A DRAWING VIOLATES THE SEAL OF A LICENSED ARCHITECT AS A VIOLATION OF SECTION 2009 SUBSECTION 6 OF THE NEW YORK STATE EDUCATION LAW.



TITLE SHEET
Proj. No. C2349.00
Date 01/18/2024

TS