

1 FIRST FLOOR REFLECTED CEILING PLAN - AREA B
SCALE: 1/8" = 1'-0"



REFLECTED CEILING PLAN LEGEND

- ACT-1 2x2 SUSPENDED ACOUSTICAL CEILING TILE SYSTEM 1
- GYPSUM BOARD CEILING/SOFFIT, PAINTED
- COOLER / FREEZER CEILING
- 24"x48" LIGHT FIXTURE, REFER TO E-DRAWINGS.
- STRIP LIGHT FIXTURE, REFER TO E-DRAWINGS.
- WALL-MOUNTED FIRE ALARM W/ STROBE, REFER TO E-DRAWINGS.
- WALL-MOUNTED FIRE ALARM BELL, REFER TO E-DRAWINGS.
- WALL-MOUNTED BLUE LIGHT STROBE, REFER TO E-DRAWINGS.
- SMOKE DETECTOR, REFER TO E-DRAWINGS.
- CEILING-MOUNTED SPEAKER, REFER TO E-DRAWINGS.
- CAMERA, REFER TO E-DRAWINGS.
- EXIT SIGN, REFER TO E-DRAWINGS.
- EMERGENCY LIGHT UNIT, REFER TO E-DRAWINGS.
- CEILING/SOFFIT ELEVATION (A.F.F.)

GENERAL REFLECTED CEILING PLAN NOTES

- 1 ALL SUSPENDED CEILING TILE SYSTEMS TO BE CENTERED IN RESPECTIVE SPACE UNLESS NOTED OTHERWISE.
 - 2 FIXTURES SHOWN ON THE REFLECTED CEILING PLANS ARE SHOWN FOR DESIGN INTENT PURPOSES ONLY. COORDINATE WITH M-, E-, AND P- CONTRACTORS FOR EXACT FIXTURE TYPES, QUANTITIES, AND LOCATIONS. PROVIDE PERIMETER CEILING GRID FOR EQUIPMENT SIZES LARGER THAN CEILING GRID SPACING. INSTALL EQUIPMENT SUCH THAT LOCATION IS CENTERED IN RELATION TO CEILING TILES, AS APPLICABLE.
 - 3 FOR ALL CEILINGS WITH EXPOSED STRUCTURE TO BE PAINTED, ALL CONDUIT, PIPING, AND DUCTWORK TO BE INSTALLED PRIOR TO PAINTING AND PAINTED TO MATCH EXPOSED STRUCTURE.
- RENOVATION KEYNOTES**
- C1 PROVIDE IN-WALL INSULATION INFILL AT AREA OF EXHAUST DUCTWORK REMOVAL. PROVIDE PATCH AT WALL OPENING TO MATCH EXISTING ADJACENT SURFACES. EXISTING EXTERIOR EXHAUST GRILLE AND WALL SLEEVE TO REMAIN. REFER TO DETAIL 6/A700 FOR ADDITIONAL INFORMATION.
 - C2 PROVIDE EXTERIOR WALL INFILL AT AREA OF EXHAUST FAN REMOVAL. PROVIDE PATCH AT WALL OPENING TO MATCH EXISTING ADJACENT SURFACES. REFER TO DETAIL 6/A700 FOR ADDITIONAL INFORMATION.
 - C3 PROVIDE SOFFIT CONSTRUCTION INFILL AT AREA OF EXHAUST GRILLE REMOVAL. PATCH AND PAINT TO MATCH ADJACENT SURFACES.
 - C4 PROVIDE 2x2 SUSPENDED ACOUSTICAL CEILING TILE AND GRID SYSTEM TO EXTENTS INDICATED. COORDINATE INSTALLATION OF CEILING MOUNTED EQUIPMENT AND FIXTURES WITH M- AND E-CONTRACTORS.
 - C5 PROVIDE METAL STUD AND GYPSUM BOARD SOFFIT TO EXTENTS INDICATED. COORDINATE INSTALLATION OF SOFFIT MOUNTED EQUIPMENT AND FIXTURES WITH M- AND E-CONTRACTORS. PAINT PT-1, TYP. U.L.G.
 - C6 EXHAUST FAN AND DUCT PENETRATION TO BE PROVIDED BY M-CONTRACTOR. PATCH AND PAINT EXPOSED WALL SURFACES AROUND ENLARGED WALL OPENING TO MATCH EXISTING. SEAL AROUND PENETRATION TO PROVIDE WEATHERTIGHT CONDITION. COORDINATE WITH M-CONTRACTOR IN FIELD.
 - C7 PROVIDE SOFFIT WALL CONSTRUCTION INFILL AT AREA OF SOFFIT REMOVAL. PATCH AND PAINT TO MATCH ADJACENT CONSTRUCTION.


THIS SHEET INCORPORATES COLOR GRAPHICS WHICH INDICATE IMPORTANT INFORMATION AND SHALL BE PRINTED IN COLOR IF REPRODUCED BY A CONTRACTOR.

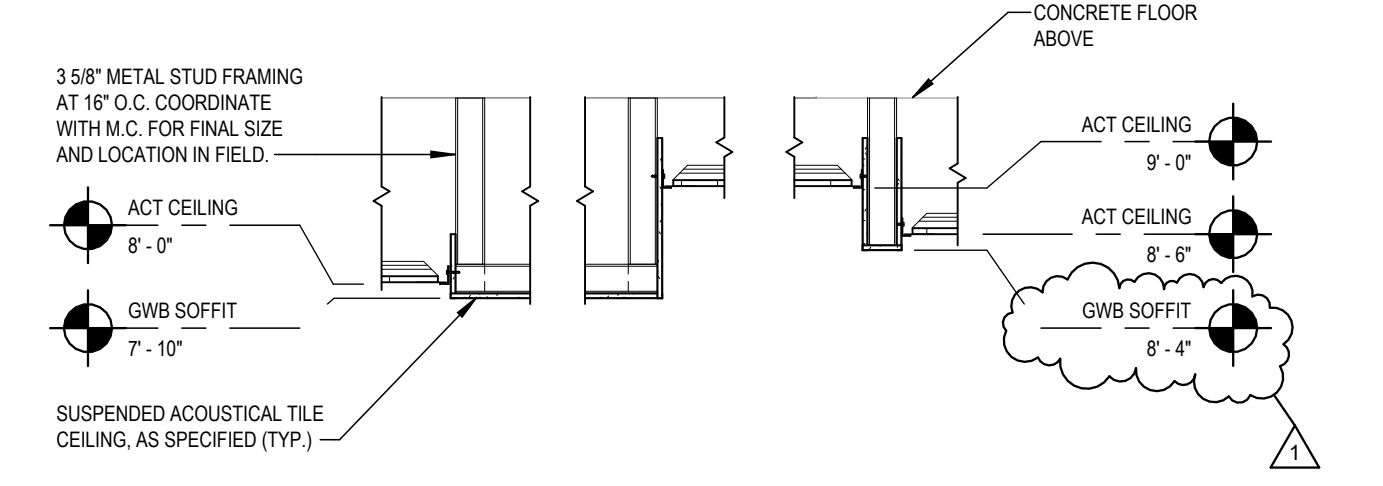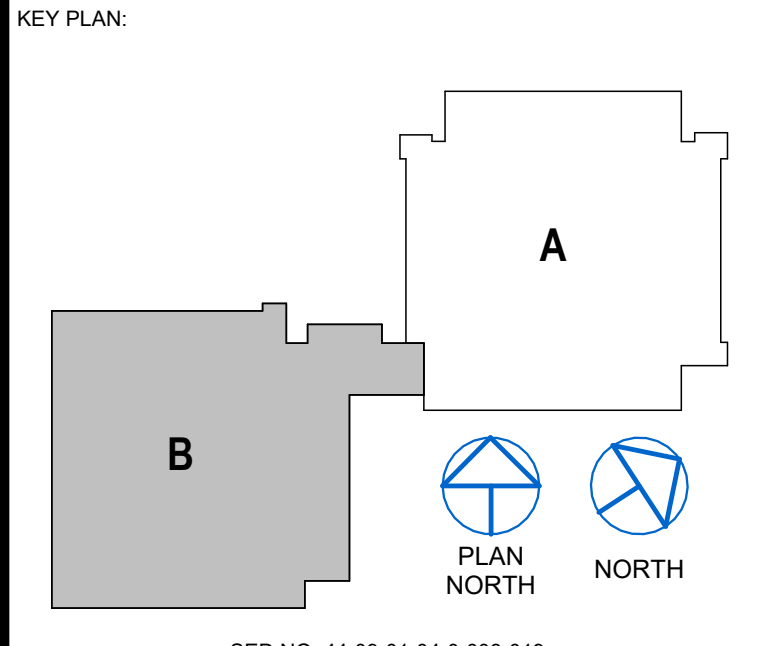

NOTE:


1. PROVIDE CORNER BEAD AT GWB CORNER TRANSITIONS. (TYP.)
2. PROVIDE PAINT FINISH TO EXPOSED HORIZONTAL AND VERTICAL GWB SOFFIT SURFACES AS SCHEDULED. PATCH AND PAINT EXISTING WALL SURFACES AFFECTED BY WORK TO MATCH EXISTING.

2 KITCHEN SOFFIT DETAIL
SCALE: 1/2" = 1'-0"

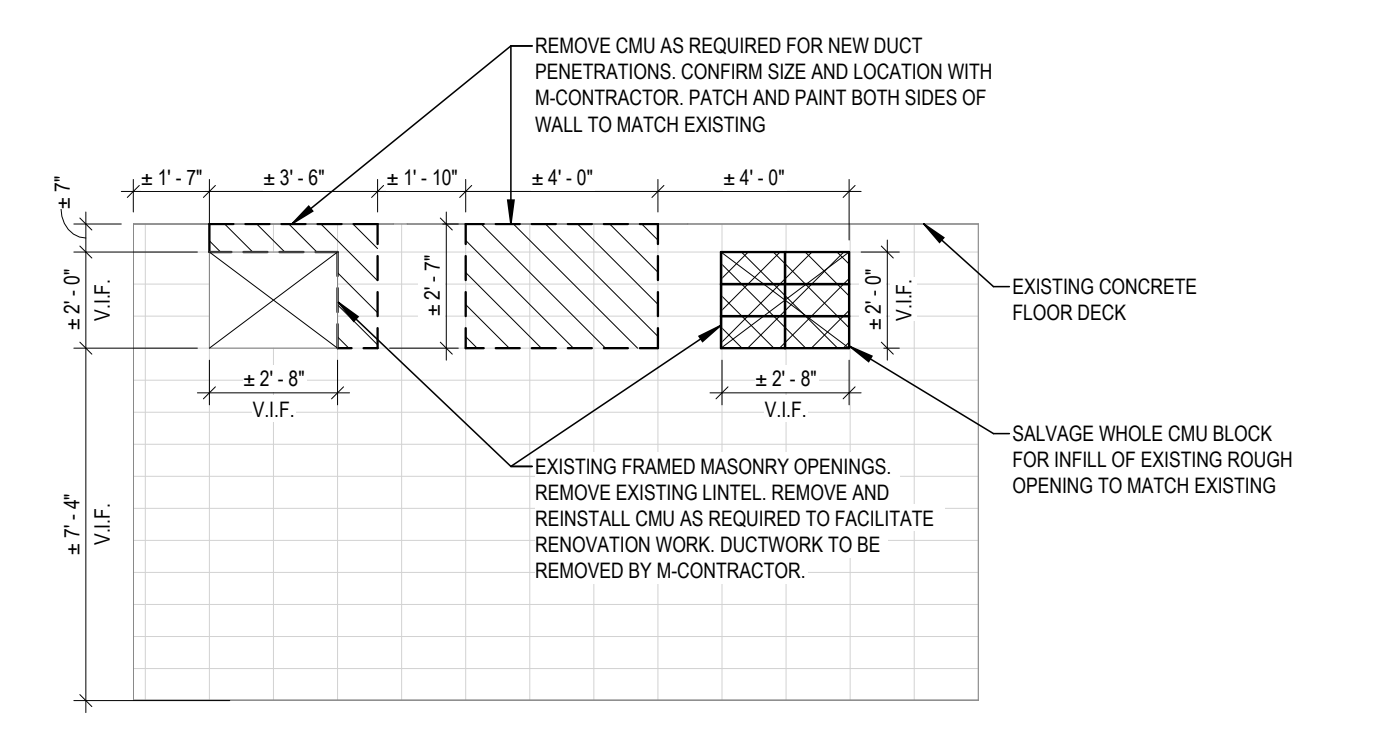

3 STORAGE 170A - ELEVATION
SCALE: 1/4" = 1'-0"

BCA Architects & Engineers
Watertown | Ithaca | Saratoga Springs
Rochester | Troy | Binghamton
WWW.THEBCAGROUP.COM

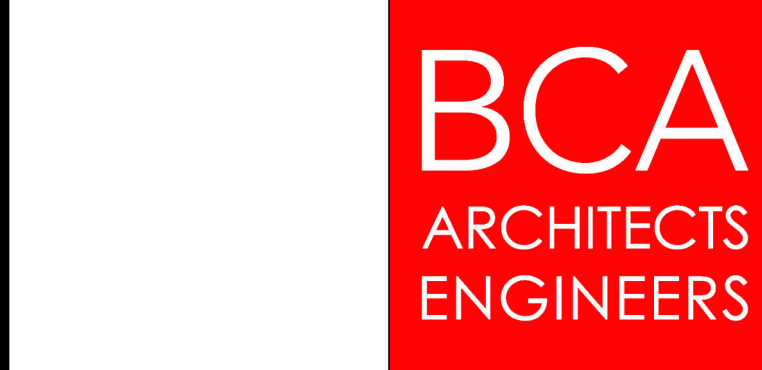

HIGHLAND FALLS - FORT MONTGOMERY CSD
ALTERATIONS TO:
JAMES I. O'NEILL HIGH SCHOOL
HIGHLAND FALLS - ORANGE COUNTY - NEW YORK

REV	DATE	DESCRIPTION
1	01/10/2025	BID ADDENDUM NO. 1

DRAWN BY: JAD PROJECT NUMBER: 2022-138 PH3
CHECKED BY: MCB DATE: 12/20/2024

FIRST FLOOR REFLECTED CEILING PLAN - AREA B
BUILDING NUMBER: HS SHEET NUMBER: A300