

3A I^A Document 6716 - 2004

Request for Information ("RFI")

TO:

Brian T. Dunn, AIA
KG+D Architects, PC
285 Main Street
Mount Kisco, NY 10549

FROM: Phil Pignatelli**PROJECT:**

Harrison, Town-Village Recrea
270 Harrison Avenue
Harrison, NY 10528

ISSUE DATE: 11/12/24

RFI No. 007

tion Center Phase 2

PROJECT NUMBERS: 2020-1005 /**REQUESTED REPLY DATE:**
COPIES TO:**RFI DESCRIPTION:** *(Fully describe**Attached Complete RFI***REFERENCES/ATTACHMENTS:**
SPECIFICATIONS:*(List specific documents researched when seeking the information requested.)*

DRAWINGS: P-702

OTHER:

SENDER'S RECOMMENDATION:*recommended solution, including**ON: (If RFI concerns a site or construction condition, the sender may provide a cost and/or schedule considerations.)*


RECEIVER'S REPLY: *(Provide answer**to RFI, including cost and/or schedule considerations.)*

See response and marked up shop drawing below for the 3" vent route per OLA.

Brian Dunn 2024-12-06

COPIES TO

Wrote: This reply is not an authorization to proceed with work involving additional cost, time or both. If any reply requires a change to the Contract Documents, a Change Order, Construction Change Directive or a Minor Change in the work must be executed in accordance with the Contract Documents.

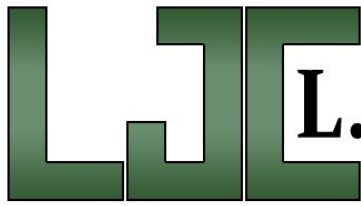

L.J. COPPOLA INC.

MECHANICAL CONTRACTORS

40 Farrington Road
Brewster, NY 10509
(914) 769-7666
Fax: (914) 769-5141
Plumbing License No. 750

PLUMBING

H.V.A.C.

PROCESS PIPING

SEWAGE TREATMENT

ESTABLISHED 1972

REQUEST FOR INFORMATION

Project: HARRISON REC CENTER PHASE 2 **Date:** 11/19/24 **Log No.:** LJC# -04

Drwg.: P-201 **Spec.:** N/A **Area:** PARKING FLOOR

Directed To: PIAZZA BROTHERS **Date Required:**

Impact:

Regarding: SUMP PIT EJECTOR VENT

REQUESTED BY: S. MCCABE/P. DOLSON **cc:**

INFORMATION REQUIRED:

Detail 3 on P-702 calls for an ejector vent to be installed for the duplex sump pit, with a note directing us to see the plans for the continuation. No continuation for the vent is shown on the plumbing plans, please advise.

RFI 007 OLA Response 12-5-2024:

Provide 3"V for sump pump. Refer to page 4 four routing.


RESPONSE:

RESPONSE BY:


RESPONSE DATE: **cc:**

Your response is requested by the date listed above. Failure to respond by this date may delay the project schedule and may have a cost impact.




EJECTOR PIT POINTS LIST		
	INPUT	OUTPUT
PUMP NO. 1 START/STOP	-	X
PUMP NO. 2 START/STOP	-	X
HIGH WATER ALARM	X	-
PUMP NO. 1 STATUS	-	X
PUMP NO. 2 STATUS	-	X

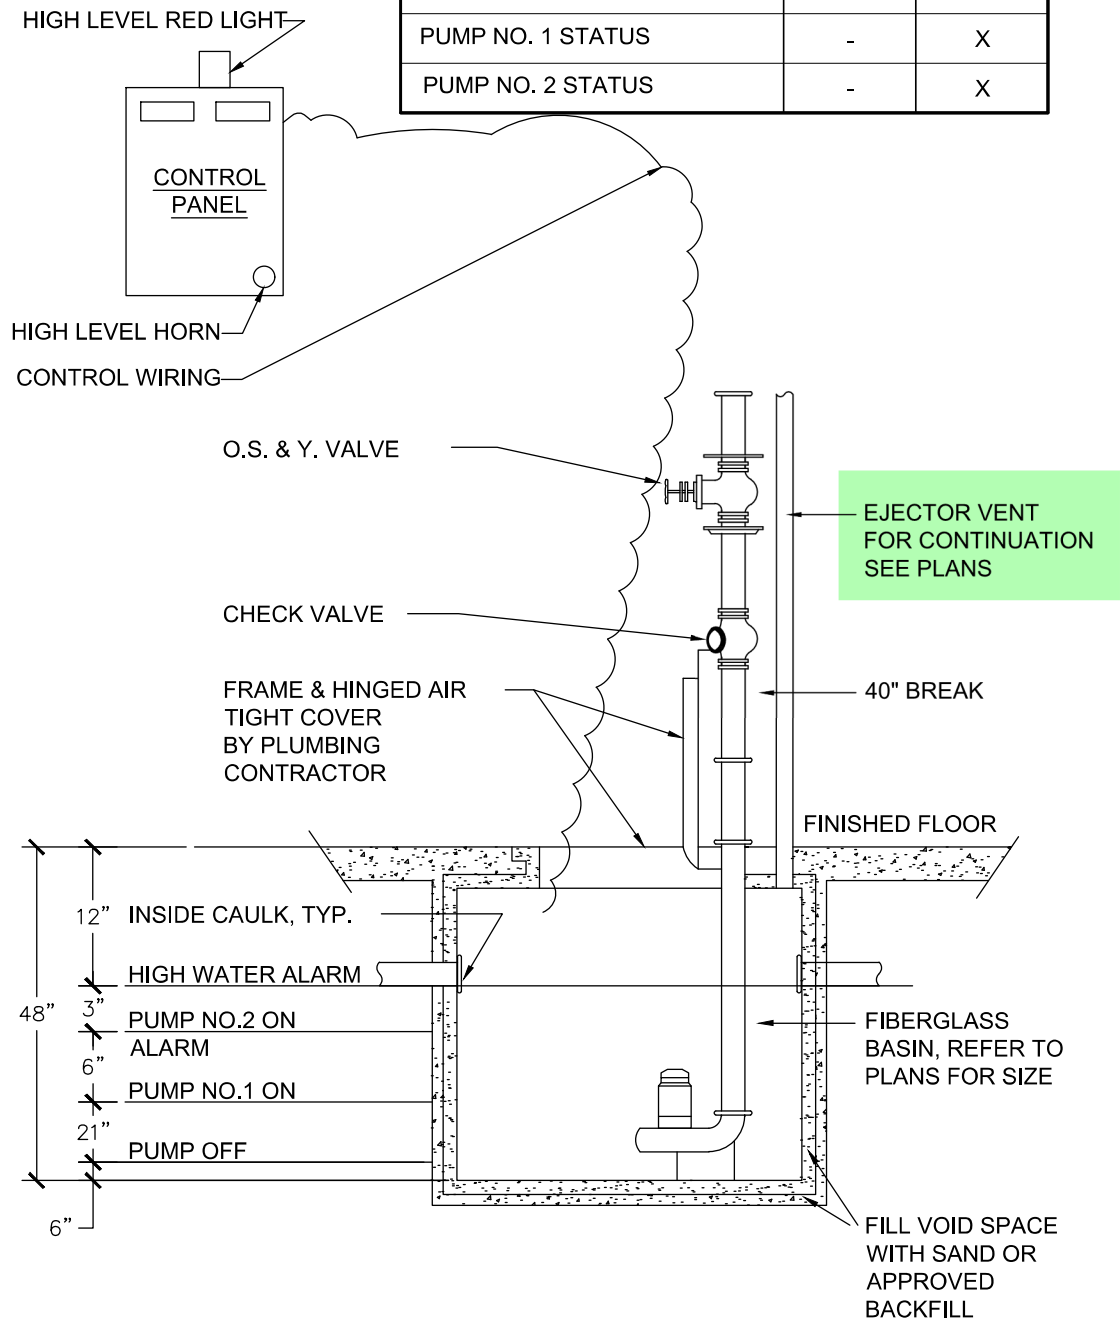

**DETAIL OF SUMP PUMP WITHIN SUMP
PIT, CONTROLS DIAGRAM AND POINTS LIST**
SCALE: NONE

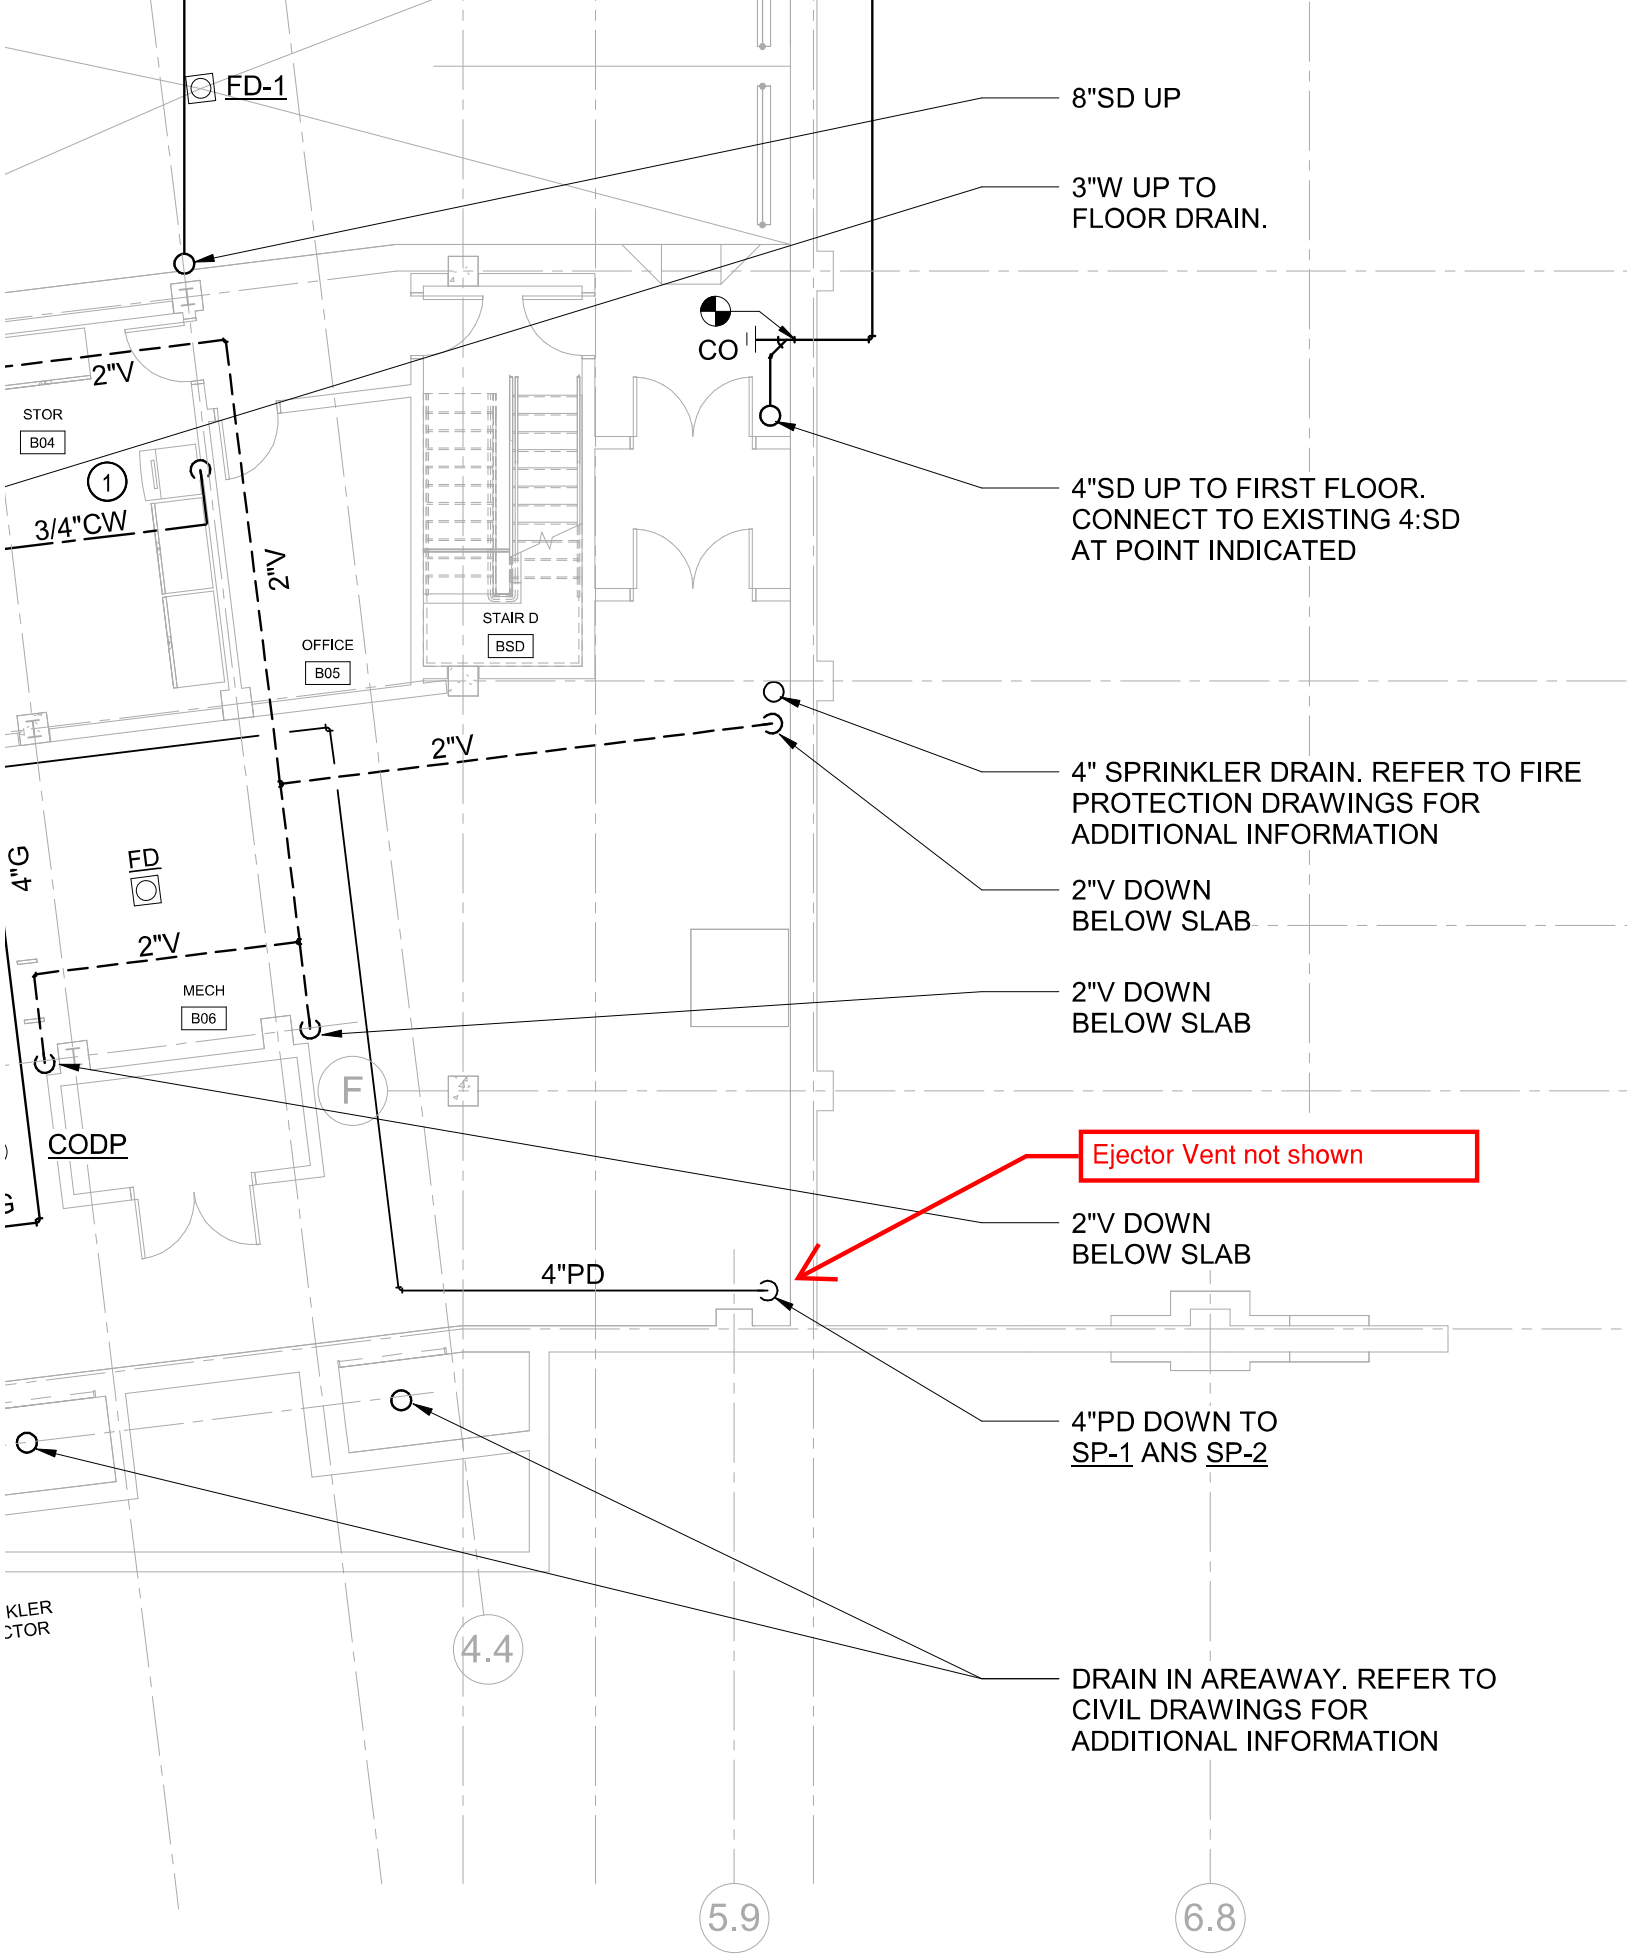

PARKING FLOOR PLAN

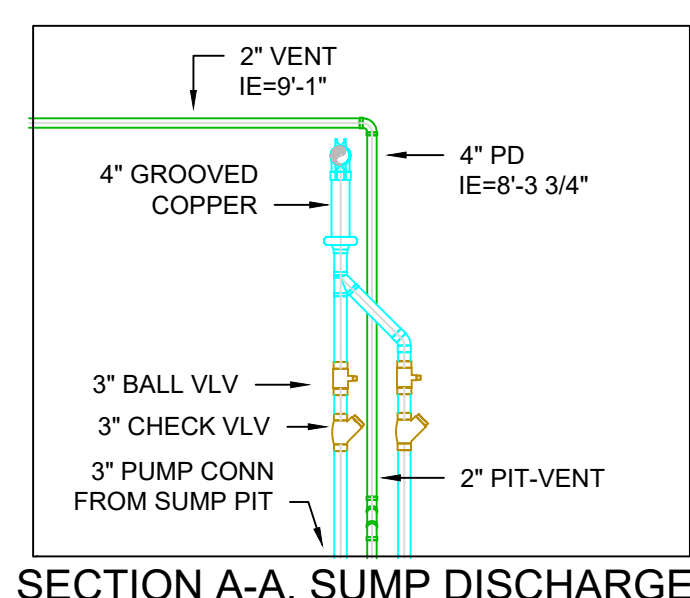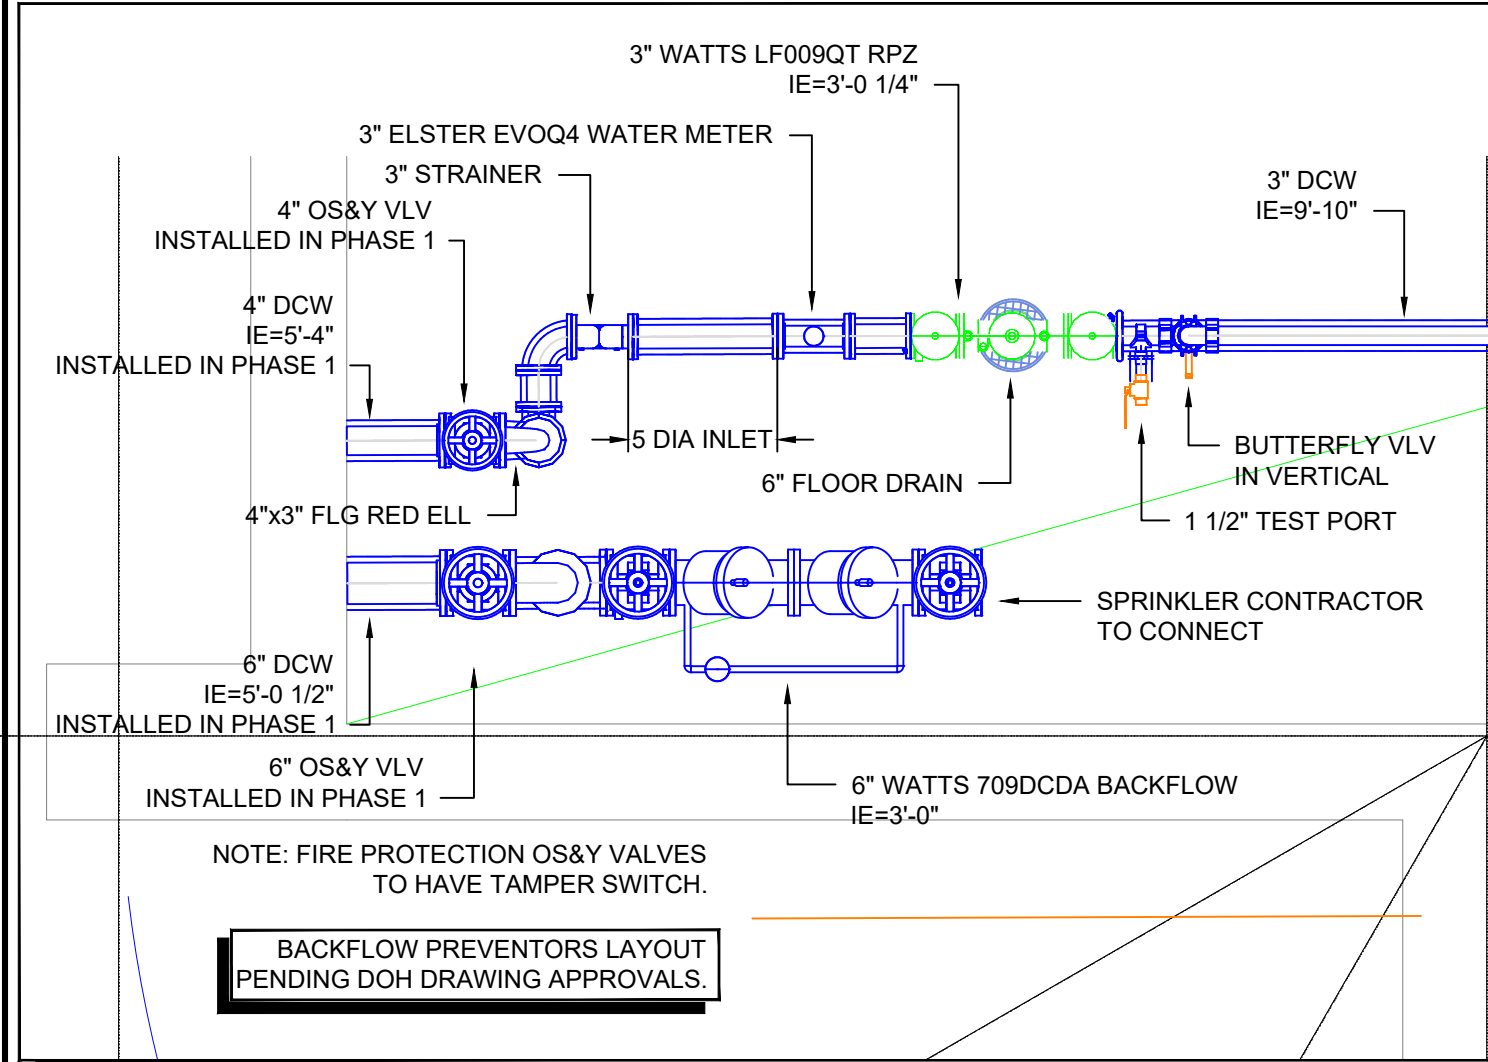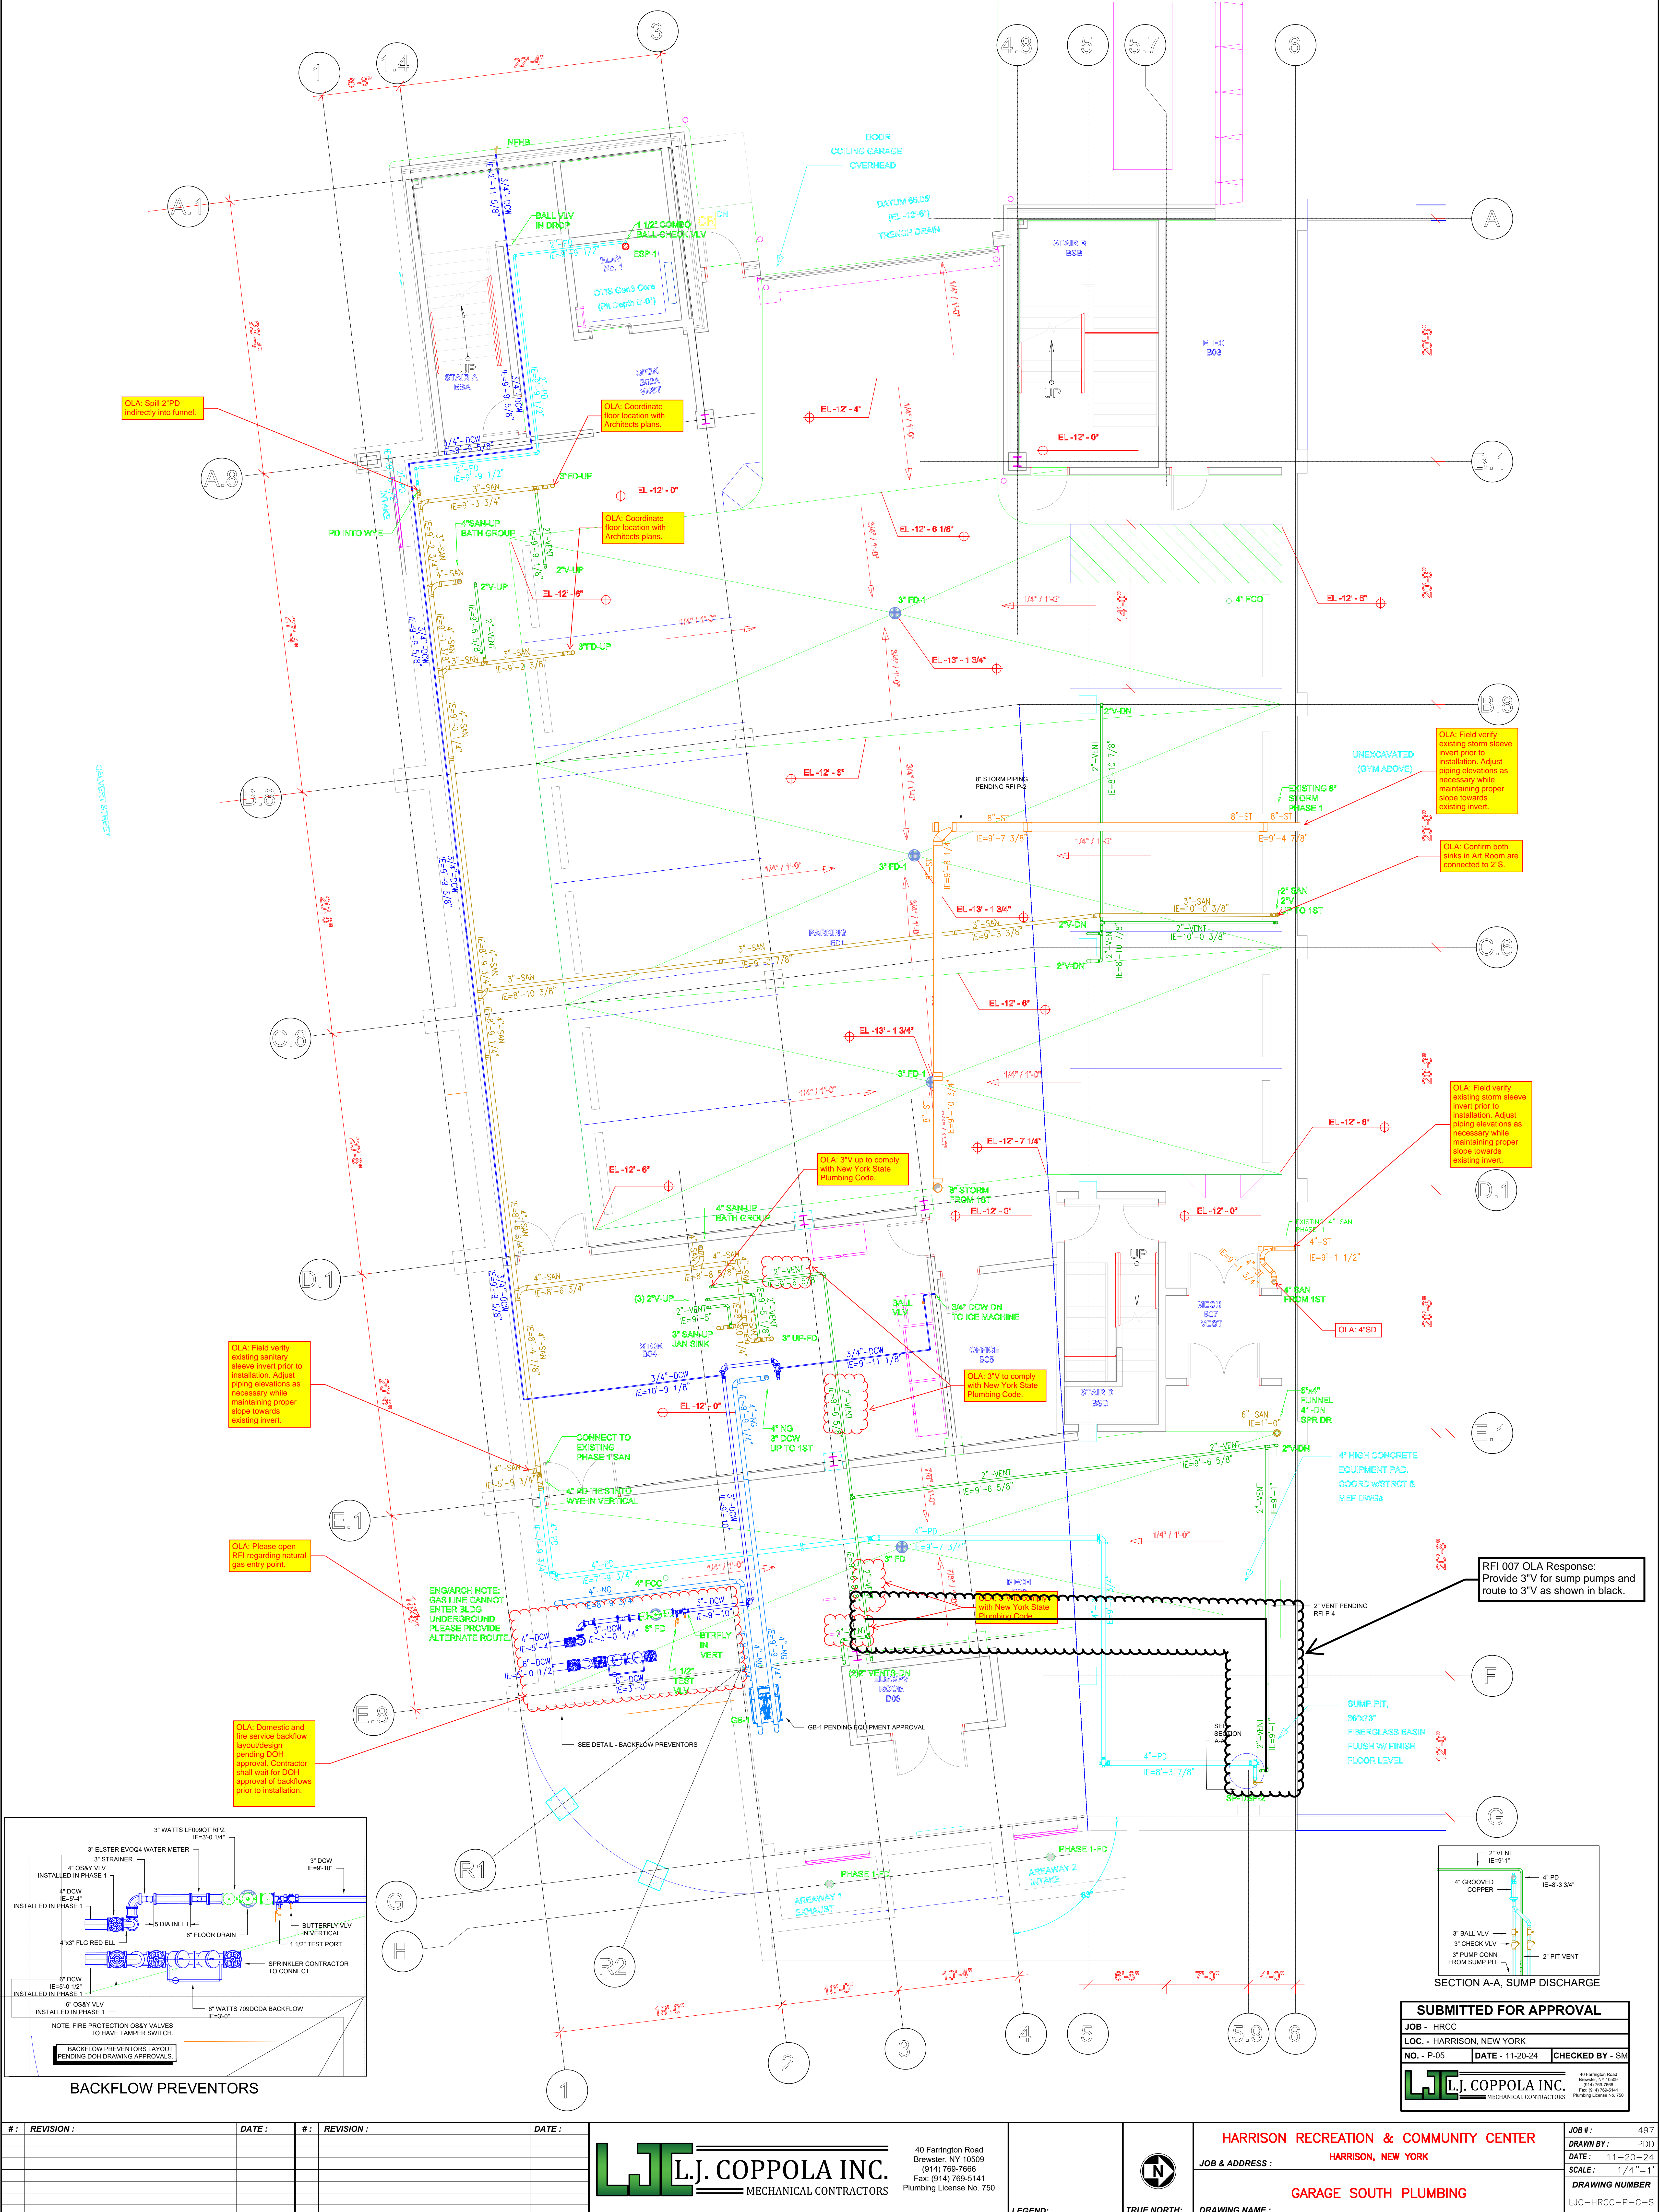

SUBMITTED FOR APPROVAL			
JOB - HRCC			
LOC. - HARRISON, NEW YORK			
NO. - P-05	DATE - 11-20-24	CHECKED BY - SM	
L.J. COPPOLA INC.		MECHANICAL CONTRACTORS	

#	REVISION	DATE	#	REVISION	DATE

L.J. COPPOLA INC.
MECHANICAL CONTRACTORS

40 Farrington Road
Brewster, NY 10509
(914) 769-7666
Fax: (914) 769-5141
Plumbing License No. 750

LEGEND:



HARRISON RECREATION & COMMUNITY CENTER
HARRISON, NEW YORK
JOB & ADDRESS:
DRAWING NAME:

JOB #: 497
DRAWN BY: PDD
DATE: 11-20-24
SCALE: 1/4"=1'
DRAWING NUMBER
LJC-HRCC-P-G-S