

BULLETIN # 2 1



DATE: December 19, 2025

TO: Piazza Inc.
Attn: Gus Carvajal

CC: Chaker Maghak, Hill Intl.,

FROM: Brian Dunn, AIA
KG+D Architects, PC

PROJECT: Harrison Recreation & Community Center – PHASE 2
Harrison, NY

RE: Gymnasium Courtline Layout Revision & Related Items

Message:

As discussed with the client, gymnasium court line layouts, quantities and colors were revised and clarified as noted as follows.

The following list is the sport court priority list. At all court line intersections/crossings, the higher priority sport court line color is required to be the top color. Any lower priority sport court line colors will require a break in the line for the higher priority sport court line to be continuous. All sport court line colors to be from the Gen-U-Line 4000 series, recommended for Tarkett flooring products.

1. Side Basketball (QTY 2): Gen-U-Line's standard Black
2. Pickleball (QTY 4): Gen-U-Line's standard White
3. Main Basketball (QTY 1): Gen-U-Line's Custom Maroon
4. Main Volleyball (QTY 1): Gen-U-Line to create custom gray to match Sherwin Williams's Dustblu SW9161.
5. Side Volleyball L&T "Ticks" (QTY 2 "courts"): Gen-U-Line to create custom blue to match Tarkett Blue from Tarkett's Poly Turf Plus Pad&Pour Color Options.

Refer to the attached sketches for further clarifications and coordination requirements. Note, previously noted volleyball sleeve locations, ceiling lighting locations, and basketball hoop locations (along with their support structures) are to be revised to match the included sketches.

Coordination with ductwork, sprinklers and other various ceiling mounted items required. Please distribute to all the required trades.

Encl: ASK-24.A ASK-24.B ASK-24.C

KG+D Architects, PC


285 Main Street, Mount Kisco, New York 10549

914.666.5900 kgdarchitects.com

COURT PRIORITY:

- 1. SIDE BASKETBALL (2 COURTS)
- 2. PICKLEBALL (4 COURTS)
- 2. MAIN BASKETBALL (1 COURT)
- 4. MAIN VOLLEYBALL (1 COURT)
- 5. SIDE VOLLEYBALL (2 "TICK" COURTS)

NOTE: AT INTERSECTIONS, THE HIGHER PRIORITY SPORT COURT COLOR WILL BE ON TOP AND THE LOWER PRIORITY WILL HAVE A BREAK IN THE LINE

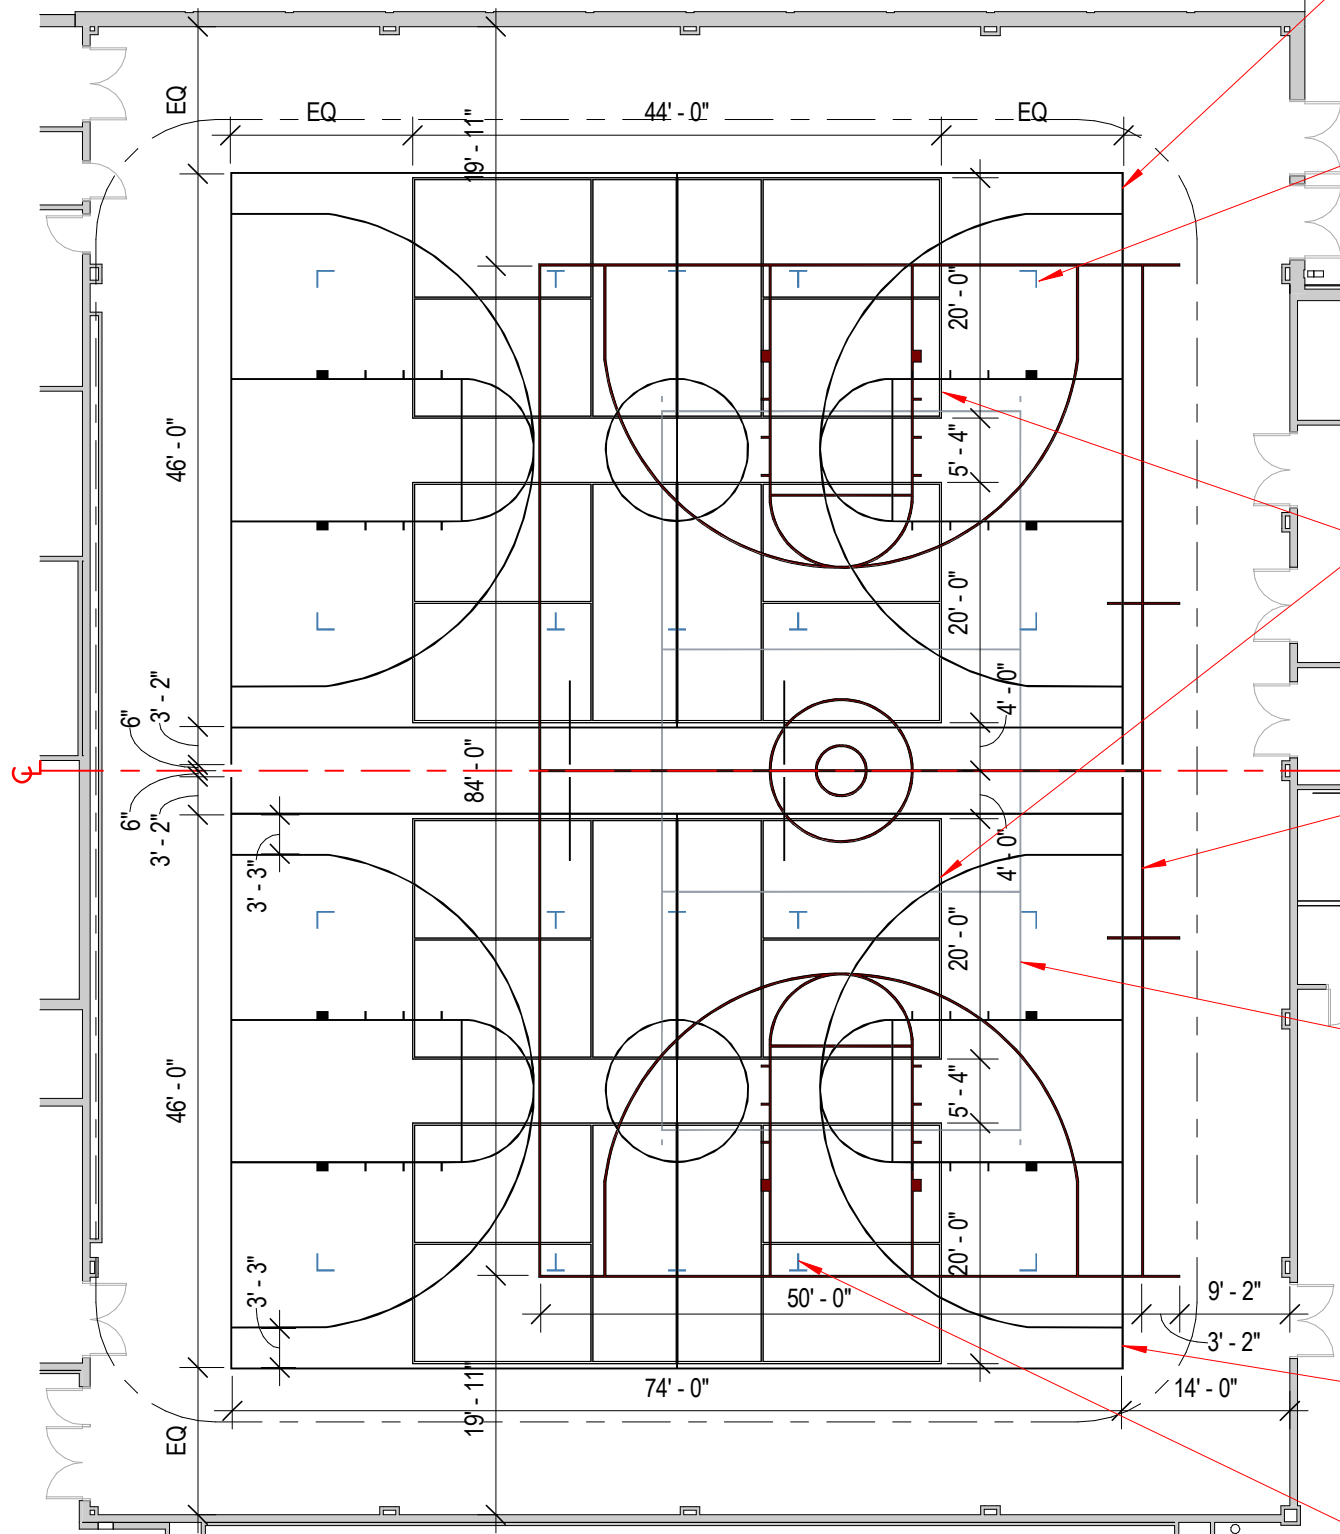

SIDE BASKETBALL COURT: 46FT x 74FT
 (NOT REGULATION SIZE)
 - BLACK COURT LINES
 (GEN-U-LINE 4000 COURT STANDARD PAINT)

SIDE VOLLEYBALL COURT: 30FT x 60FT
 (REGULATION SIZE)
 - BLUE "TICK" INTERSECTION LINES (Ls & Ts),
 SIZE 18IN LONG
 (GEN-U-LINE 4000 COURT PAINT, CUSTOM
 COLOR TO MATCH TARKETT BLUE FROM
 POLY TURF PAD&POUR COLOR OPTIONS)
 - CENTER COURT WITHIN THE SIDE
 BASKETBALL COURT

PICKLEBALL COURTS (QTY 4): 44FT x 20FT
 (REGULATION SIZE)
 - WHITE COURT LINES
 (GEN-U-LINE 4000 COURT PAINT)
 - 2 COURTS CENTERED WITHIN THE LENGTH
 OF (1) SIDE BASKETBALL COURT

MAIN BASKETBALL COURT: 50FT x 84FT
 (HIGH SCHOOL REGULATION SIZE)
 - MAROON COURT LINES
 (GEN-U-LINE 4000 COURT SUGGESTED
 CUSTOM PAINT)

MAIN VOLLEYBALL COURT: 30FT x 60FT
 (REGULATION SIZE)
 - GRAY COURT LINES
 (GEN-U-LINE 4000 COURT PAINT, CUSTOM
 COLOR TO MATCH SHERWIN WILLIAMS
 DUSTBLU SW9161)
 - CENTER COURT WITHIN THE MAIN
 BASKETBALL COURT

SIDE BASKETBALL COURT: 46FT x 74FT
 (NOT REGULATION SIZE) BLACK COURT LINES

SIDE VOLLEYBALL COURT: 30FT x 60FT
 (REGULATION SIZE)
 - BLUE "TICK" INTERSECTION LINES (Ls & Ts),
 SIZE EACH BRANCH 18IN LONG
 (GEN-U-LINE 4000 COURT PAINT, CUSTOM
 COLOR TO MATCH TARKETT BLUE FROM
 POLY TURF PAD&POUR COLOR OPTIONS)
 - CENTER COURT WITHIN THE SIDE
 BASKETBALL COURT

1 GYM COURT LINE REVISIONS
 1/16" = 1'-0"

HARRISON
 RECREATION &
 COMMUNITY
 CENTER

Town / Village of Harrison

270 Harrison Avenue Harrison,
 NY 10528



KG+D . ARCHITECTS PC
 285 MAIN STREET MOUNT KISCO . NEW YORK . 10549
 P-914.666.5900 KGDARCHITECTS.COM

Sheet Title
**COURT LINE
 REVISIONS
 COURT LOCATIONS**

Job No.	Date
2020-1005	12/19/2025

Scale	Drawn / Checked
AS NOTED	KG+D

Sheet Number
ASK-24.A


HARRISON
RECREATION &
COMMUNITY
CENTER

Town / Village of Harrison

270 Harrison Avenue Harrison,
NY 10528



KG+D . ARCHITECTS PC
285 MAIN STREET MOUNT KISCO . NEW YORK . 10549
P:914.666.5900 KGDARCHITECTS.COM

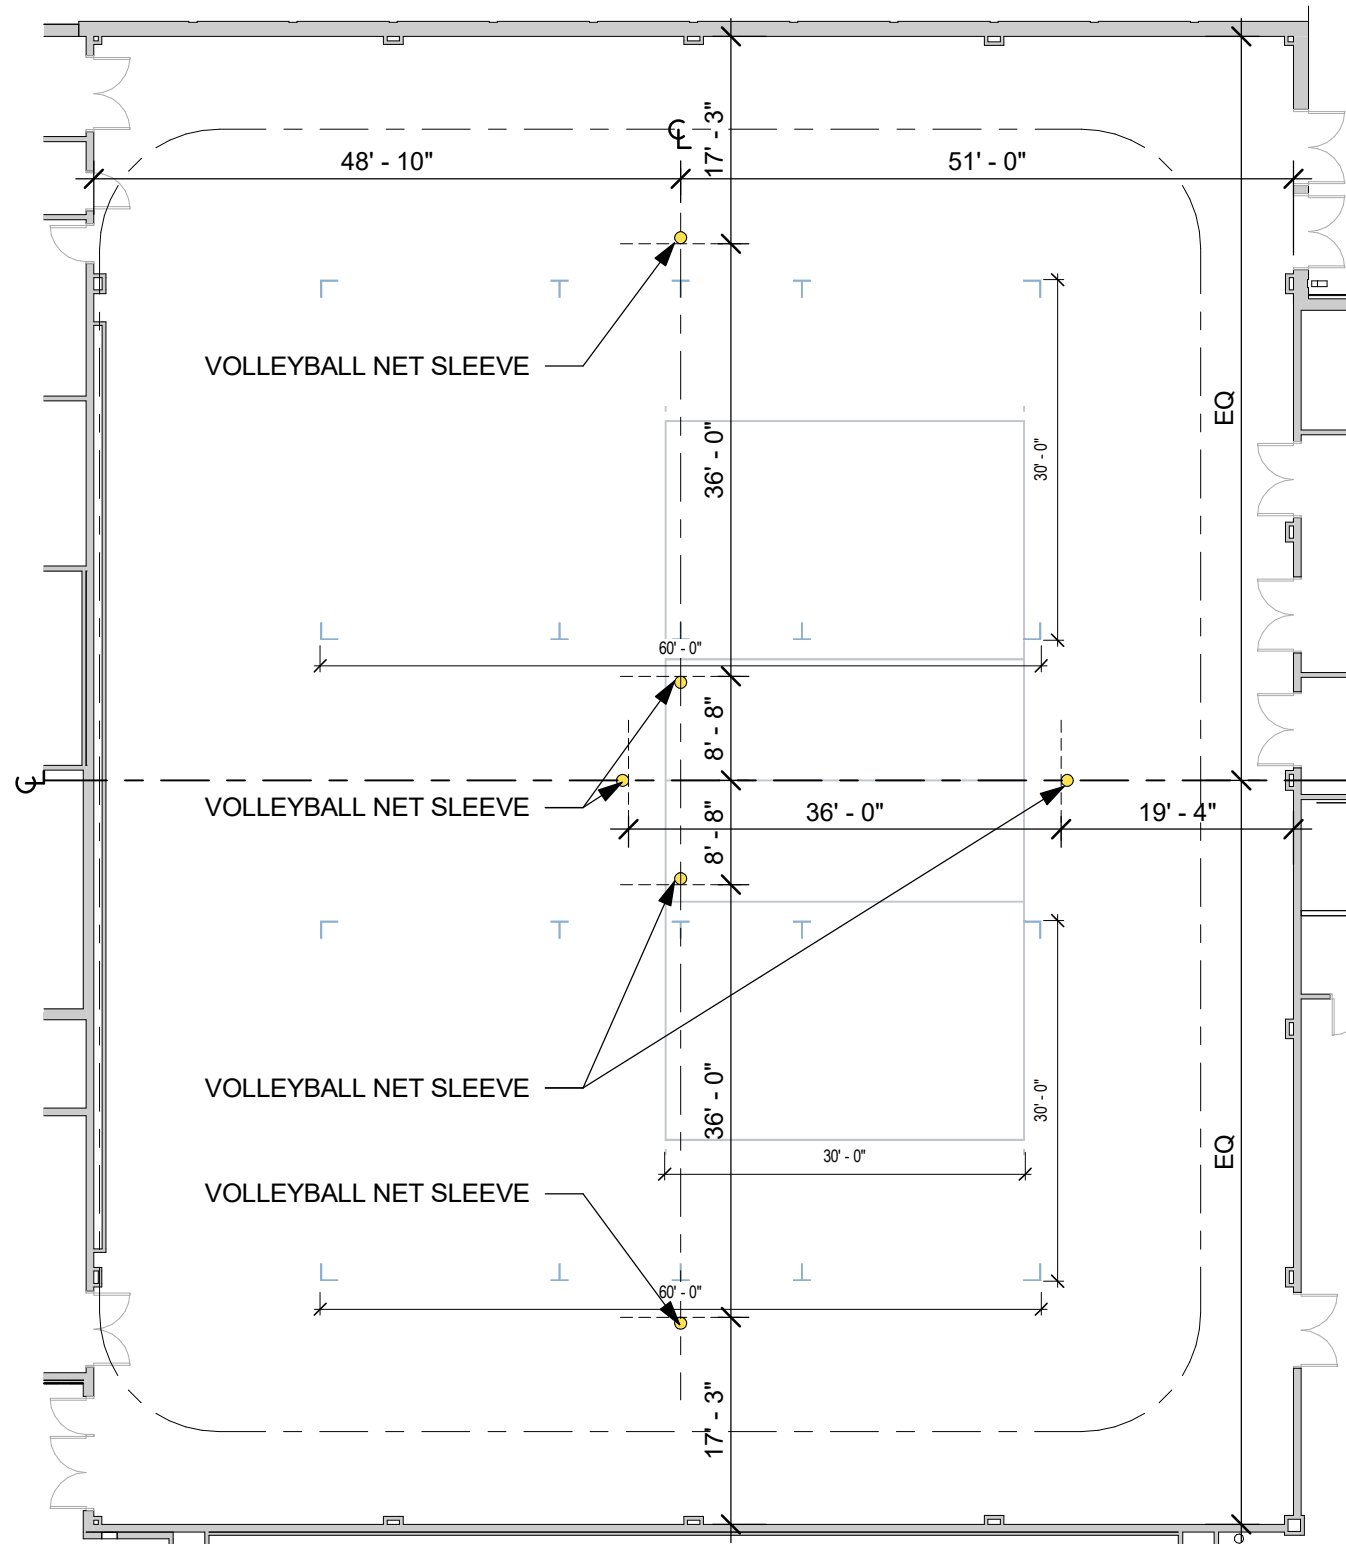

SIZE OF SLEEVE NOT TO SCALE. SEE MANUFACTURERS INFORMATION FOR THE CORRECT RADIUS/DIAMETER. THIS DRAWING IS FOR LOCATING PURPOSES ONLY. ALL DIMENSIONS TO SLEEVES ARE FROM THE COLUMN LINE TO THE CENTERLINE.

1 GYM VOLLEYBALL SLEEVES (COURT LINE UPDATE)
1/16" = 1'-0"

Sheet Title
COURT LINE
REVISIONS
VOLLEYBALL
SLEEVES

Job No. 2020-1005	Date 12/19/2025
Scale AS NOTED	Drawn / Checked KG+D

Sheet Number
ASK-24.B


HARRISON
RECREATION &
COMMUNITY
CENTER

Town / Village of Harrison

270 Harrison Avenue Harrison,
NY 10528



KG+D . ARCHITECTS PC
285 MAIN STREET MOUNT KISCO . NEW YORK . 10549
P:914.666.5900 KGDARCHITECTS.COM

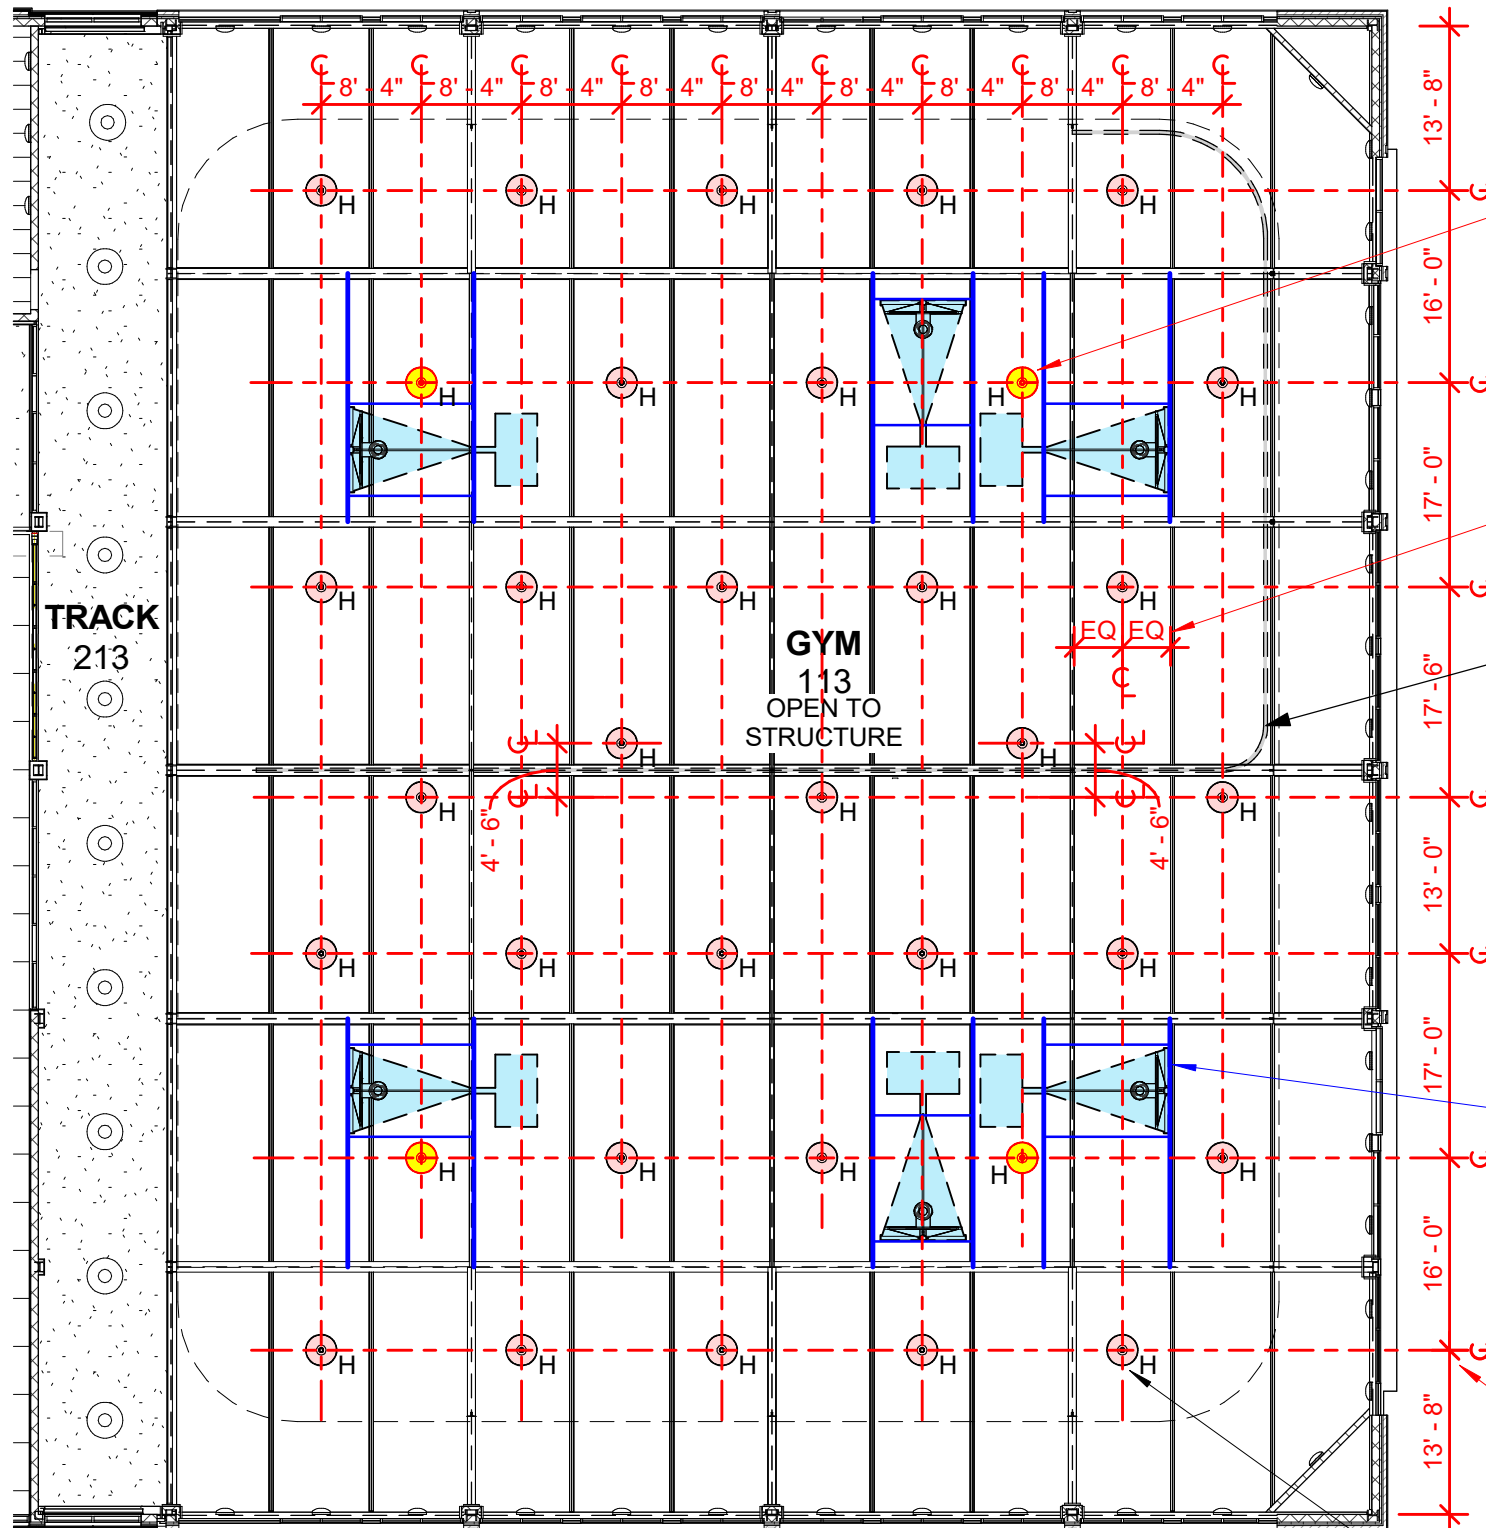

AT THE INDICATED LOCATIONS.
COORDINATE LIGHTING WITH
BASKETBALL HOOPS AND THEIR
SUPPORT STRUCTURE.
(IF ADJUSTMENTS TO LIGHTING ARE
REQUIRED, NOTIFY THE ARCHITECT)

CENTER EACH LIGHT FIXTURE BETWEEN
STRUCTURAL SUPPORTS

TRACK LOCATION OF WALK-DRAWN
CURTAIN, MOUNTED AT UNDERSIDE OF
TRUSS AND HANGER SYSTEM FROM ROOF
PURLINS. SEE SPEC FOR MORE INFO

GENERAL NOTE:
RELOCATE SPRINKLER HEADS OR OTHER
RELATED CEILING MOUNTED EQUIPMENT
FOR REVISED LIGHTING LAYOUT.
(NOTIFY THE ARCHITECT IF THERE ARE
ANY SIGNIFICANT CONFLICTS)

REVISED BASKETBALL HOOP LOCATIONS:
HOOP MANUFACTURER TO REVISE
SUPPORT STRUCTURE AS REQUIRED FOR
REVISED LOCATIONS. REMINDER TO
COORDINATE WITH THE COURT LOCATION

NEW LIGHTING SPACING:
COORDINATE SPACING WITH DUCTWORK
(IF ADJUSTMENTS TO LIGHTING ARE
REQUIRED, NOTIFY THE ARCHITECT)

1 GYM RCP REVISION (COURT LINE UPDATE)
1/16" = 1'-0"

FOR GYM 113:
TYPE H FIXTURES TO BE MOUNTED AT
25'-0" AFF TO BOTTOM OF FIXTURE - TYP

Sheet Title
COURT LINE
REVISIONS
RELATED RCP ITEMS

Job No.	Date
2020-1005	12/19/2025

Scale	Drawn / Checked
AS NOTED	KG+D

Sheet Number
ASK-24.C