

**LUMINAIRE SCHEDULE**













Sym	Qty	Catalog Number	Description	Lamp	Mounting Height	Watts
2	RSX1	LED P1 30K AFR HS	LITHONIA LIGHTING LED LUMINAIRE RSX1	LED	16'-0"	51.3

**LIGHT CONTOUR LEGEND**

0.1	0.10 Foot Candles
1	1.00 Foot Candles
2	2.00 Foot Candles

\* Photometric calculations shown on plan are in foot candles.

- LIGHTING NOTES:**
- All lighting shall be as noted on the plan or approved equal.
  - Style and finish of all luminaires to be selected by owner and approved by the YPS.
  - Proposed lights will run on photocells during regular park hours.
  - Lighting duration to be set by YPS.
  - All light fixtures to be full cutoff to comply with dark sky guidelines.

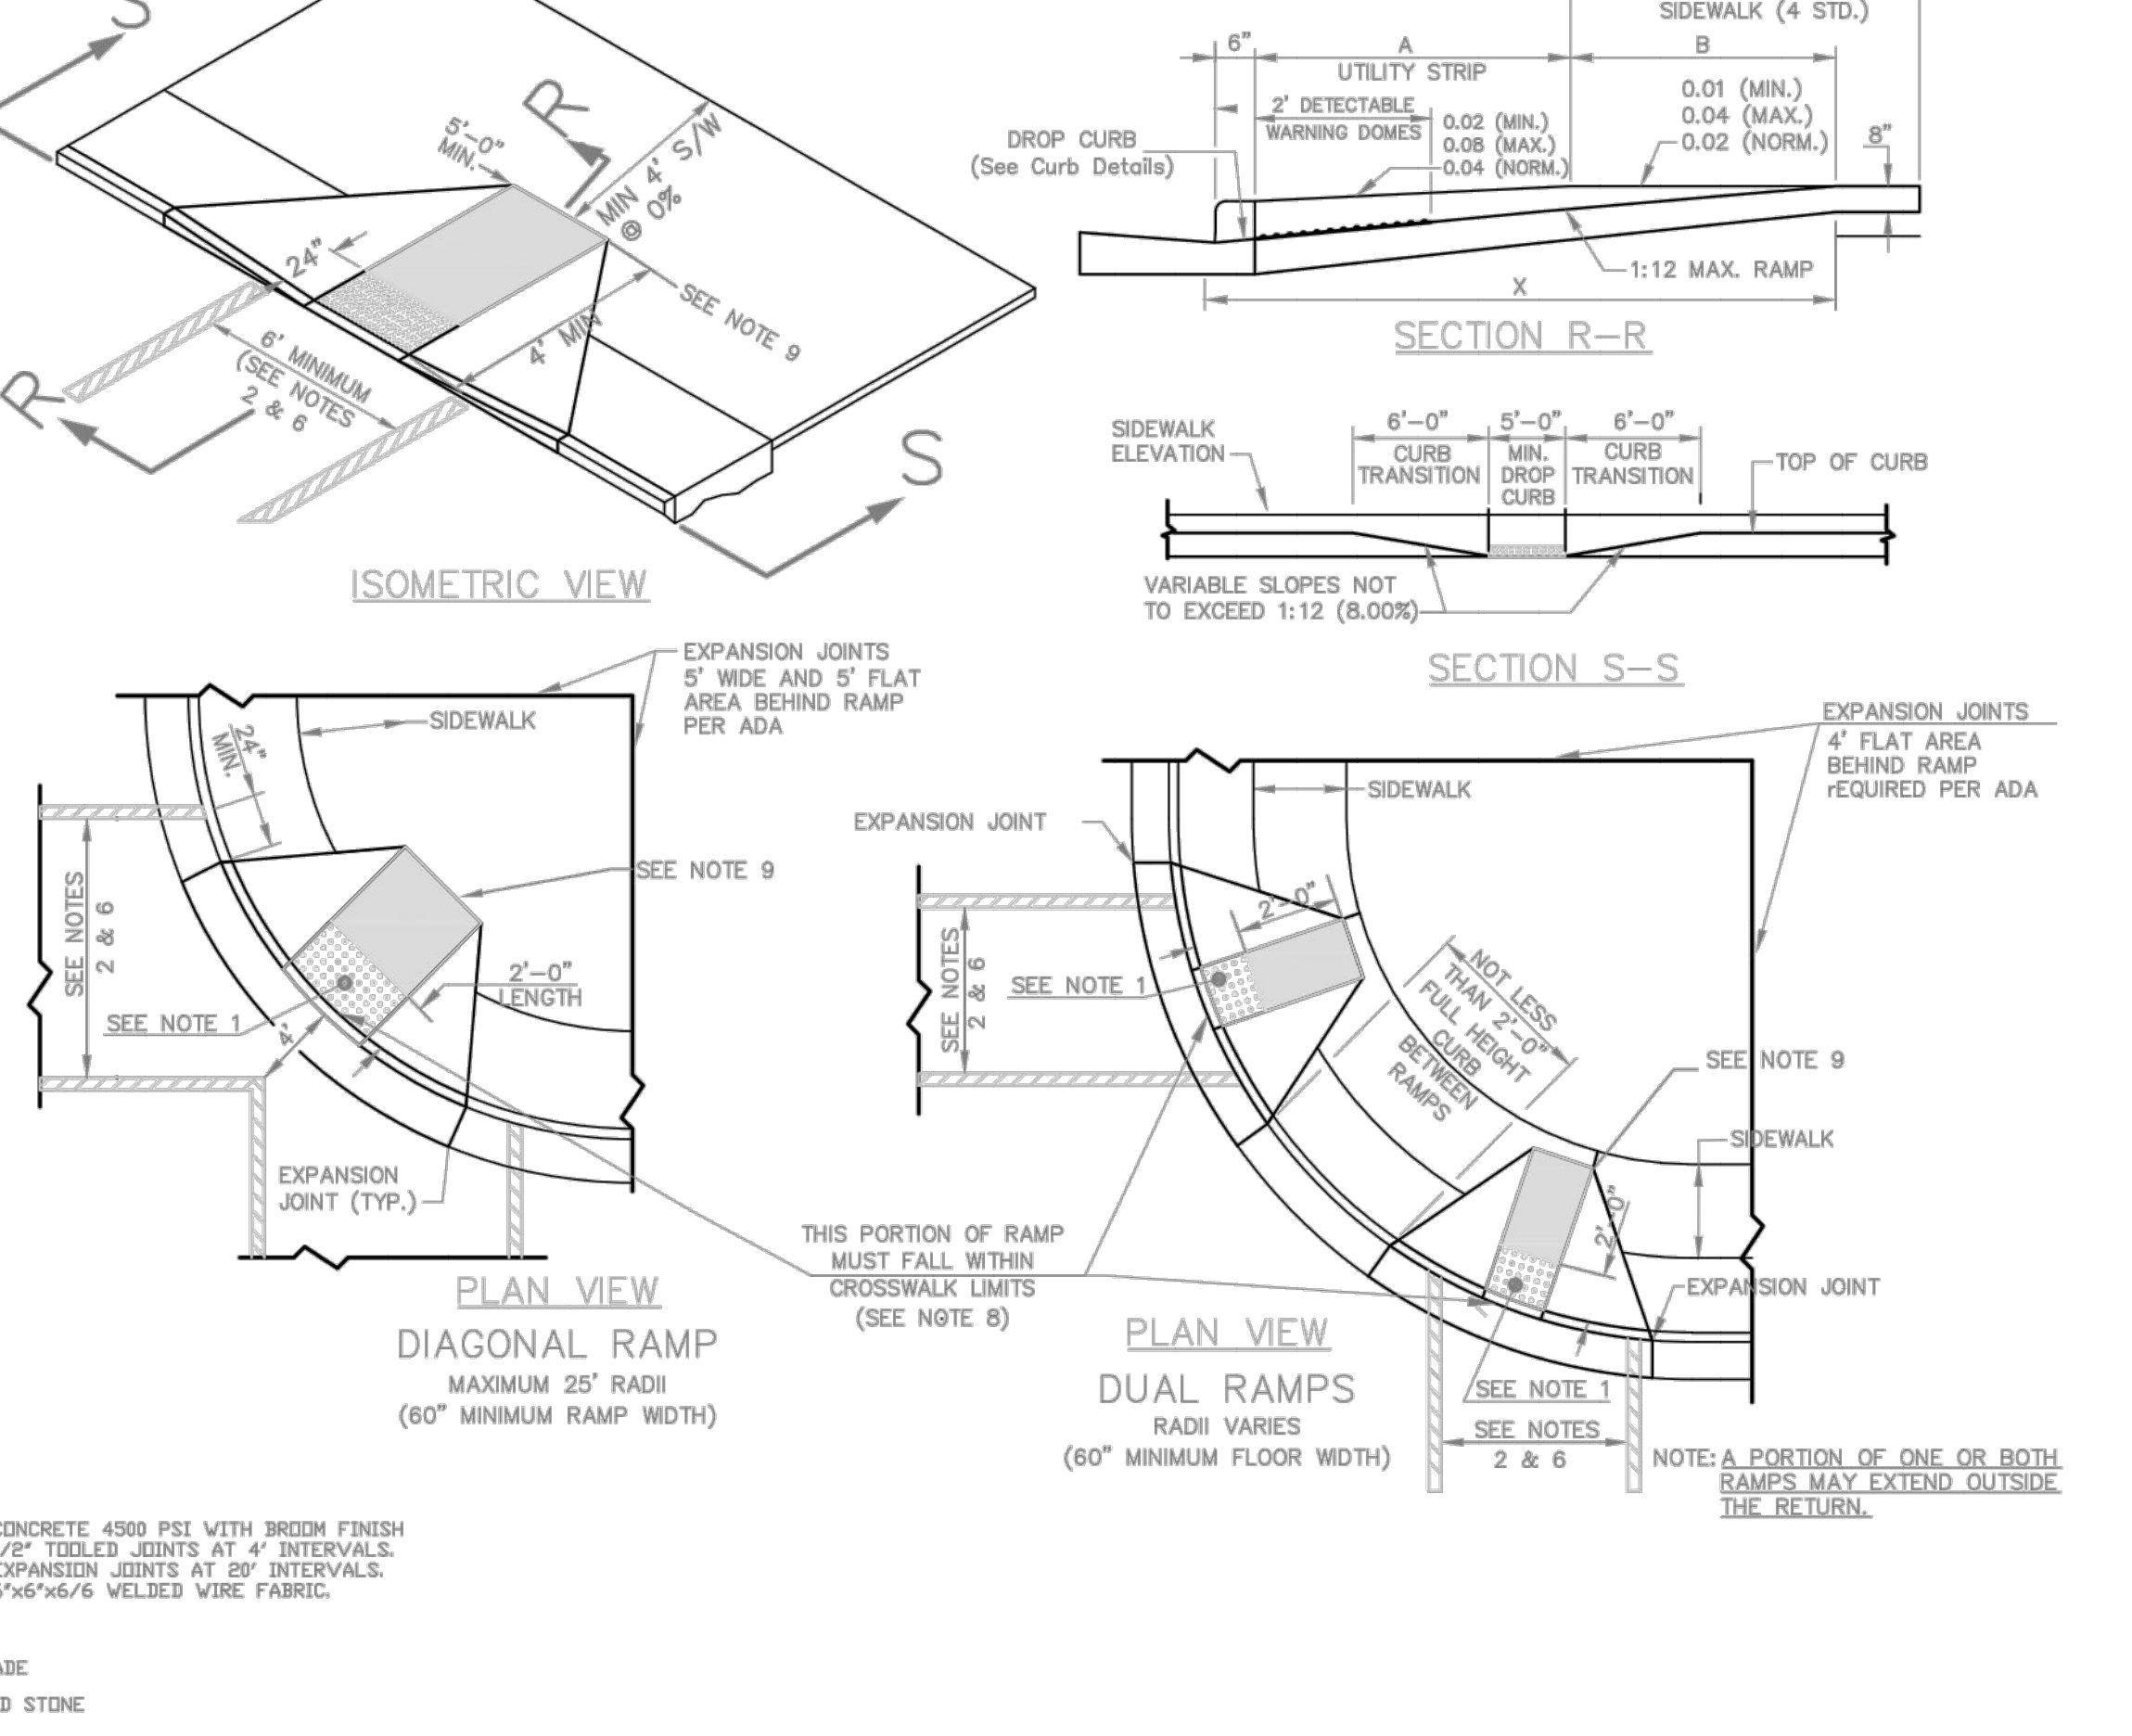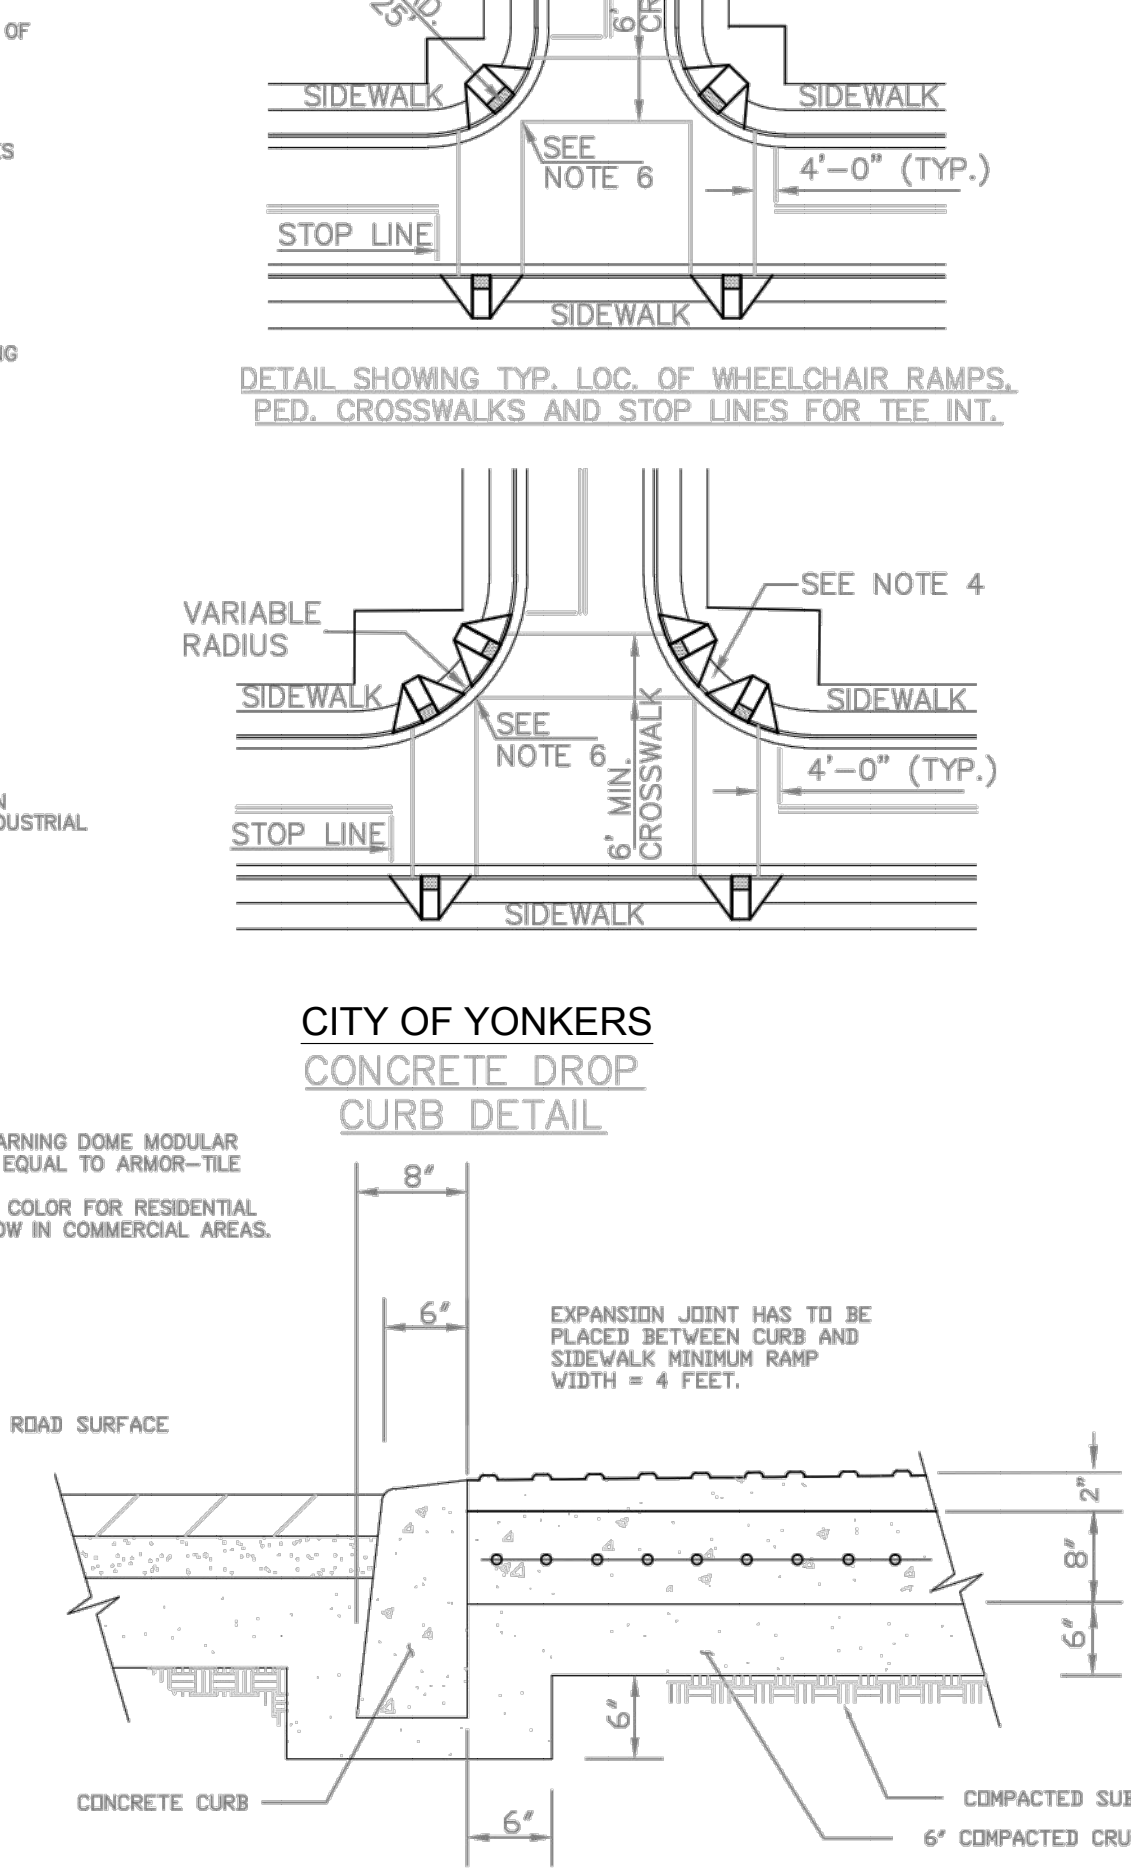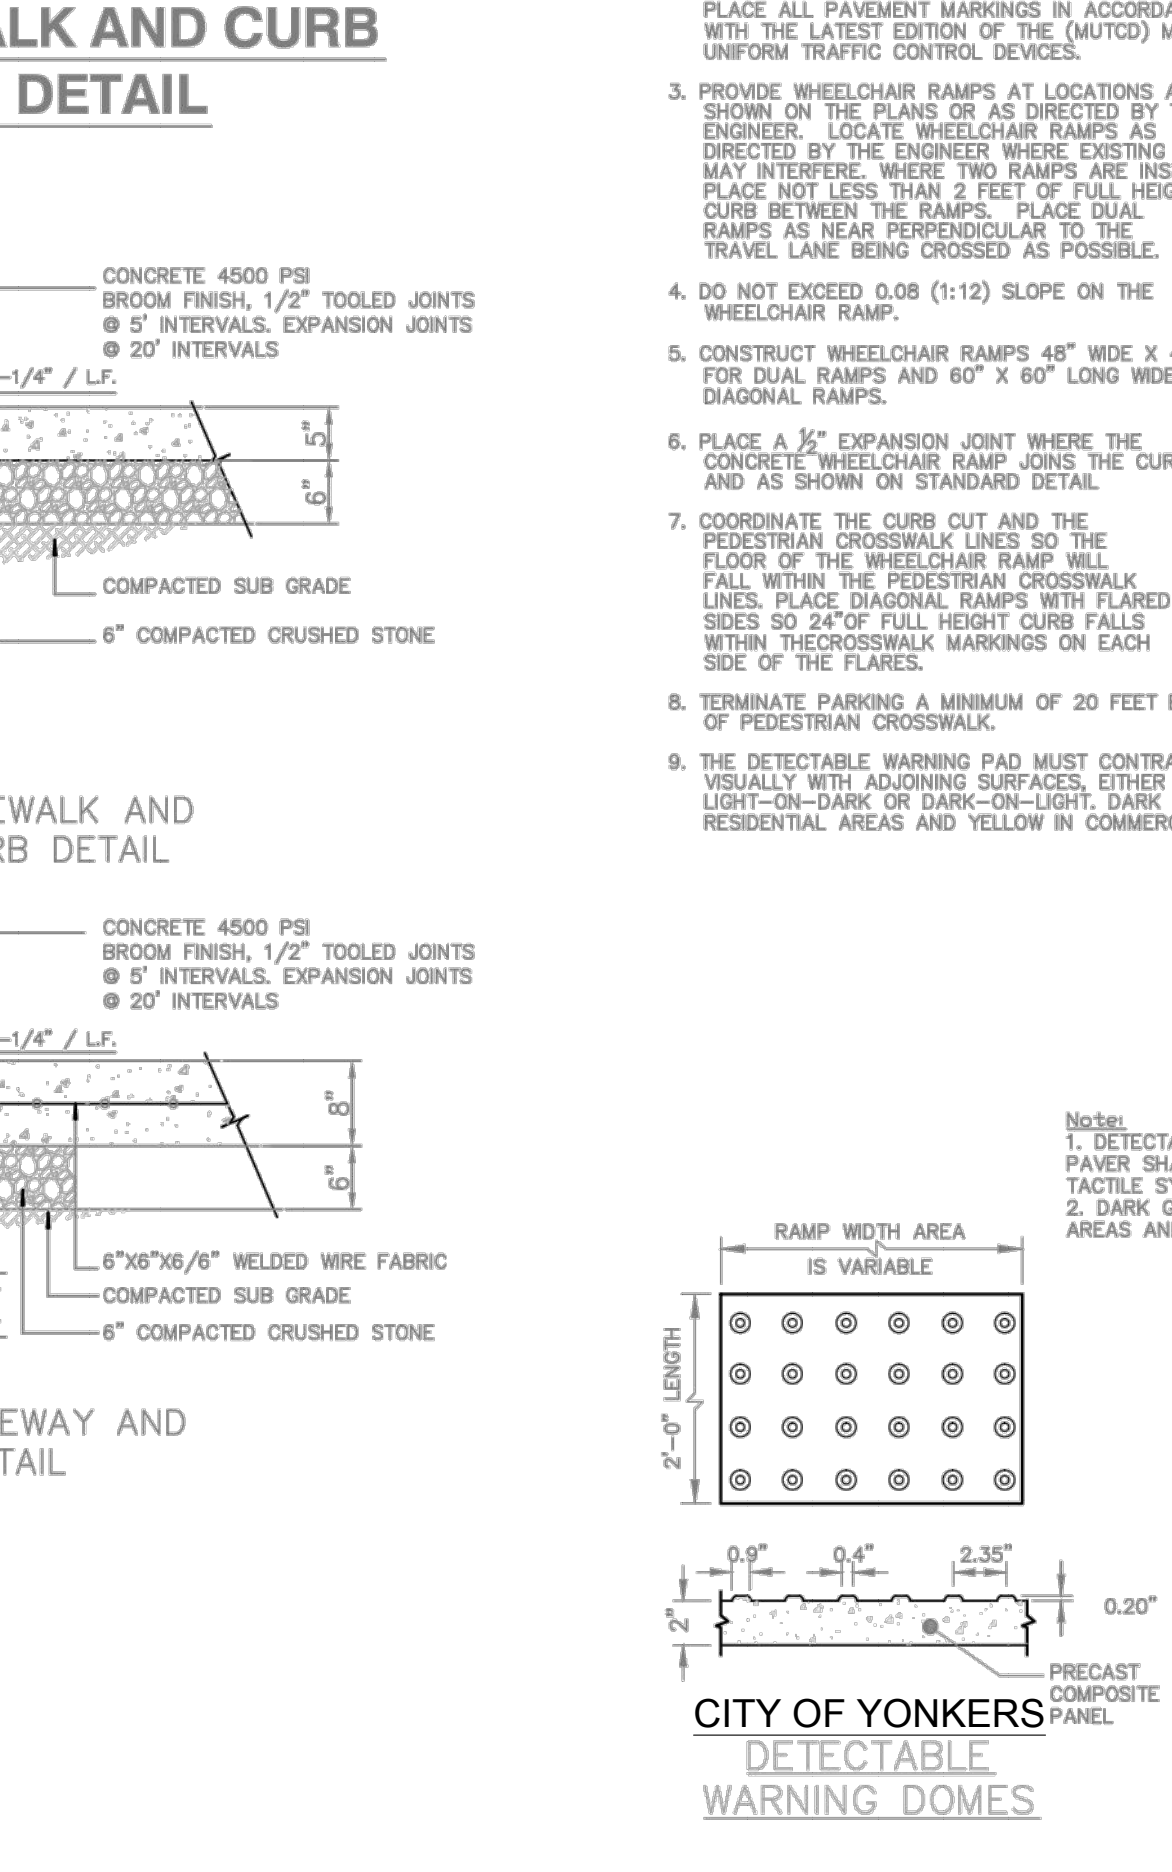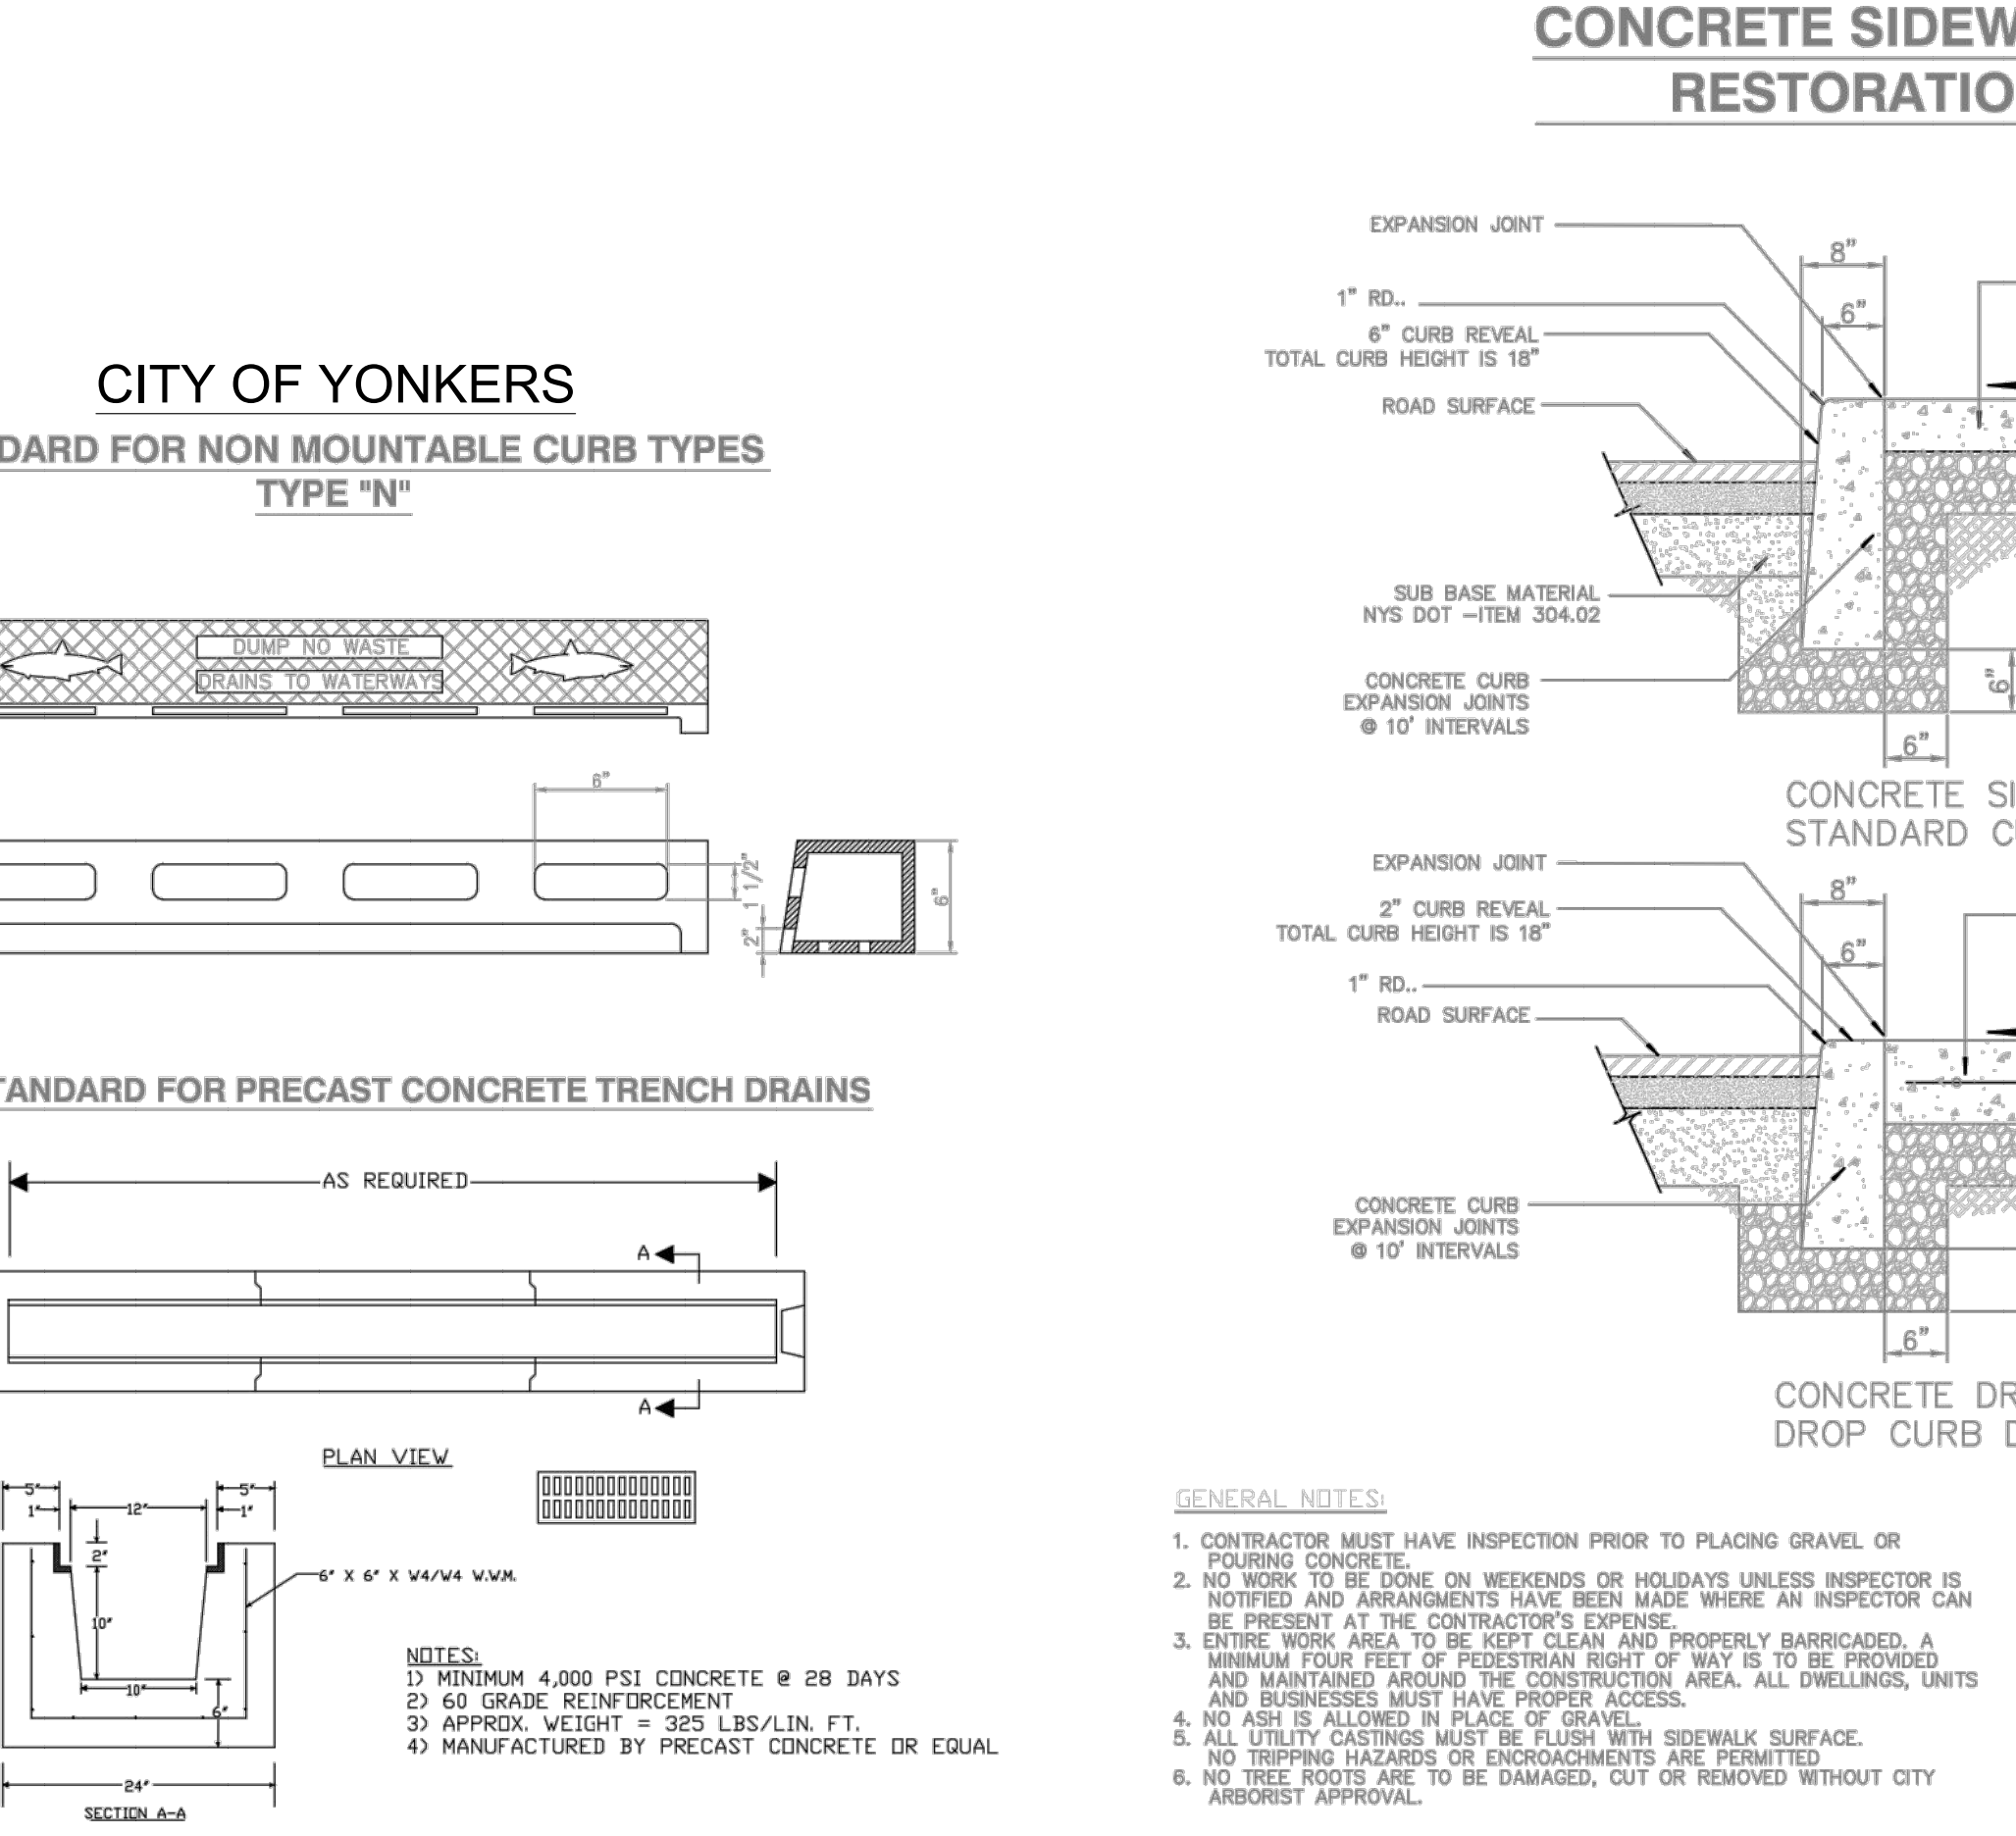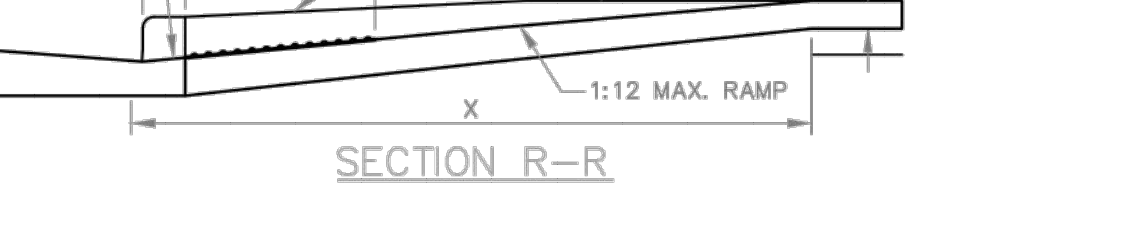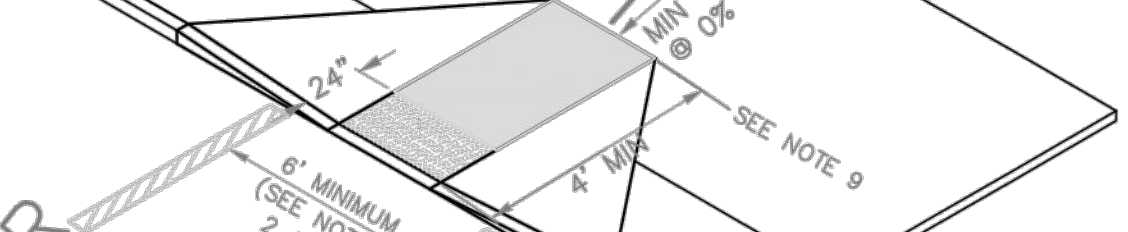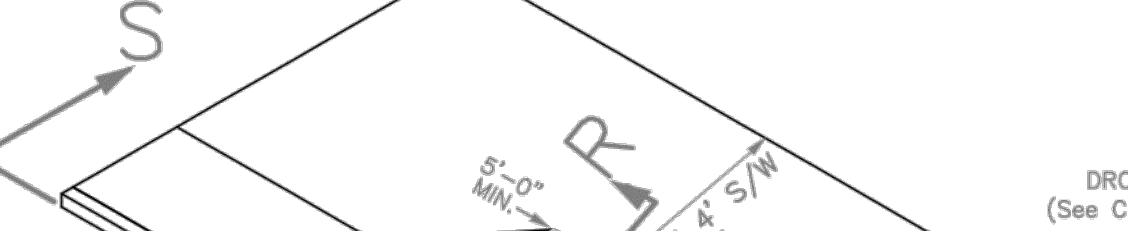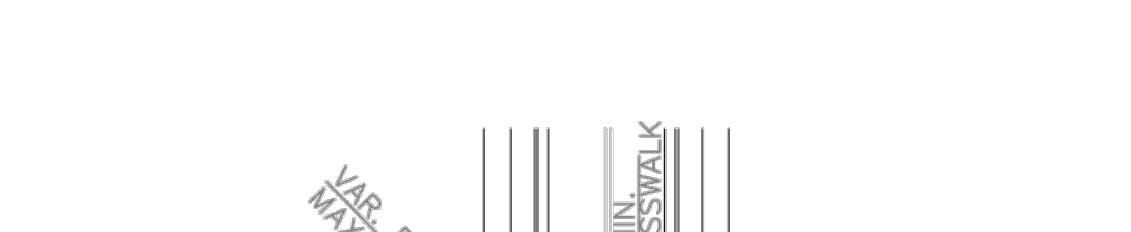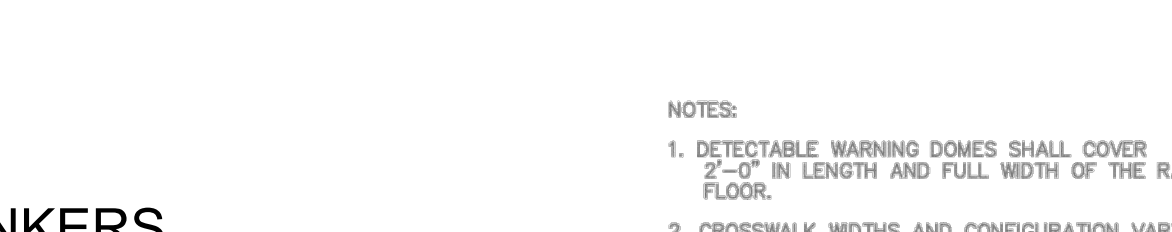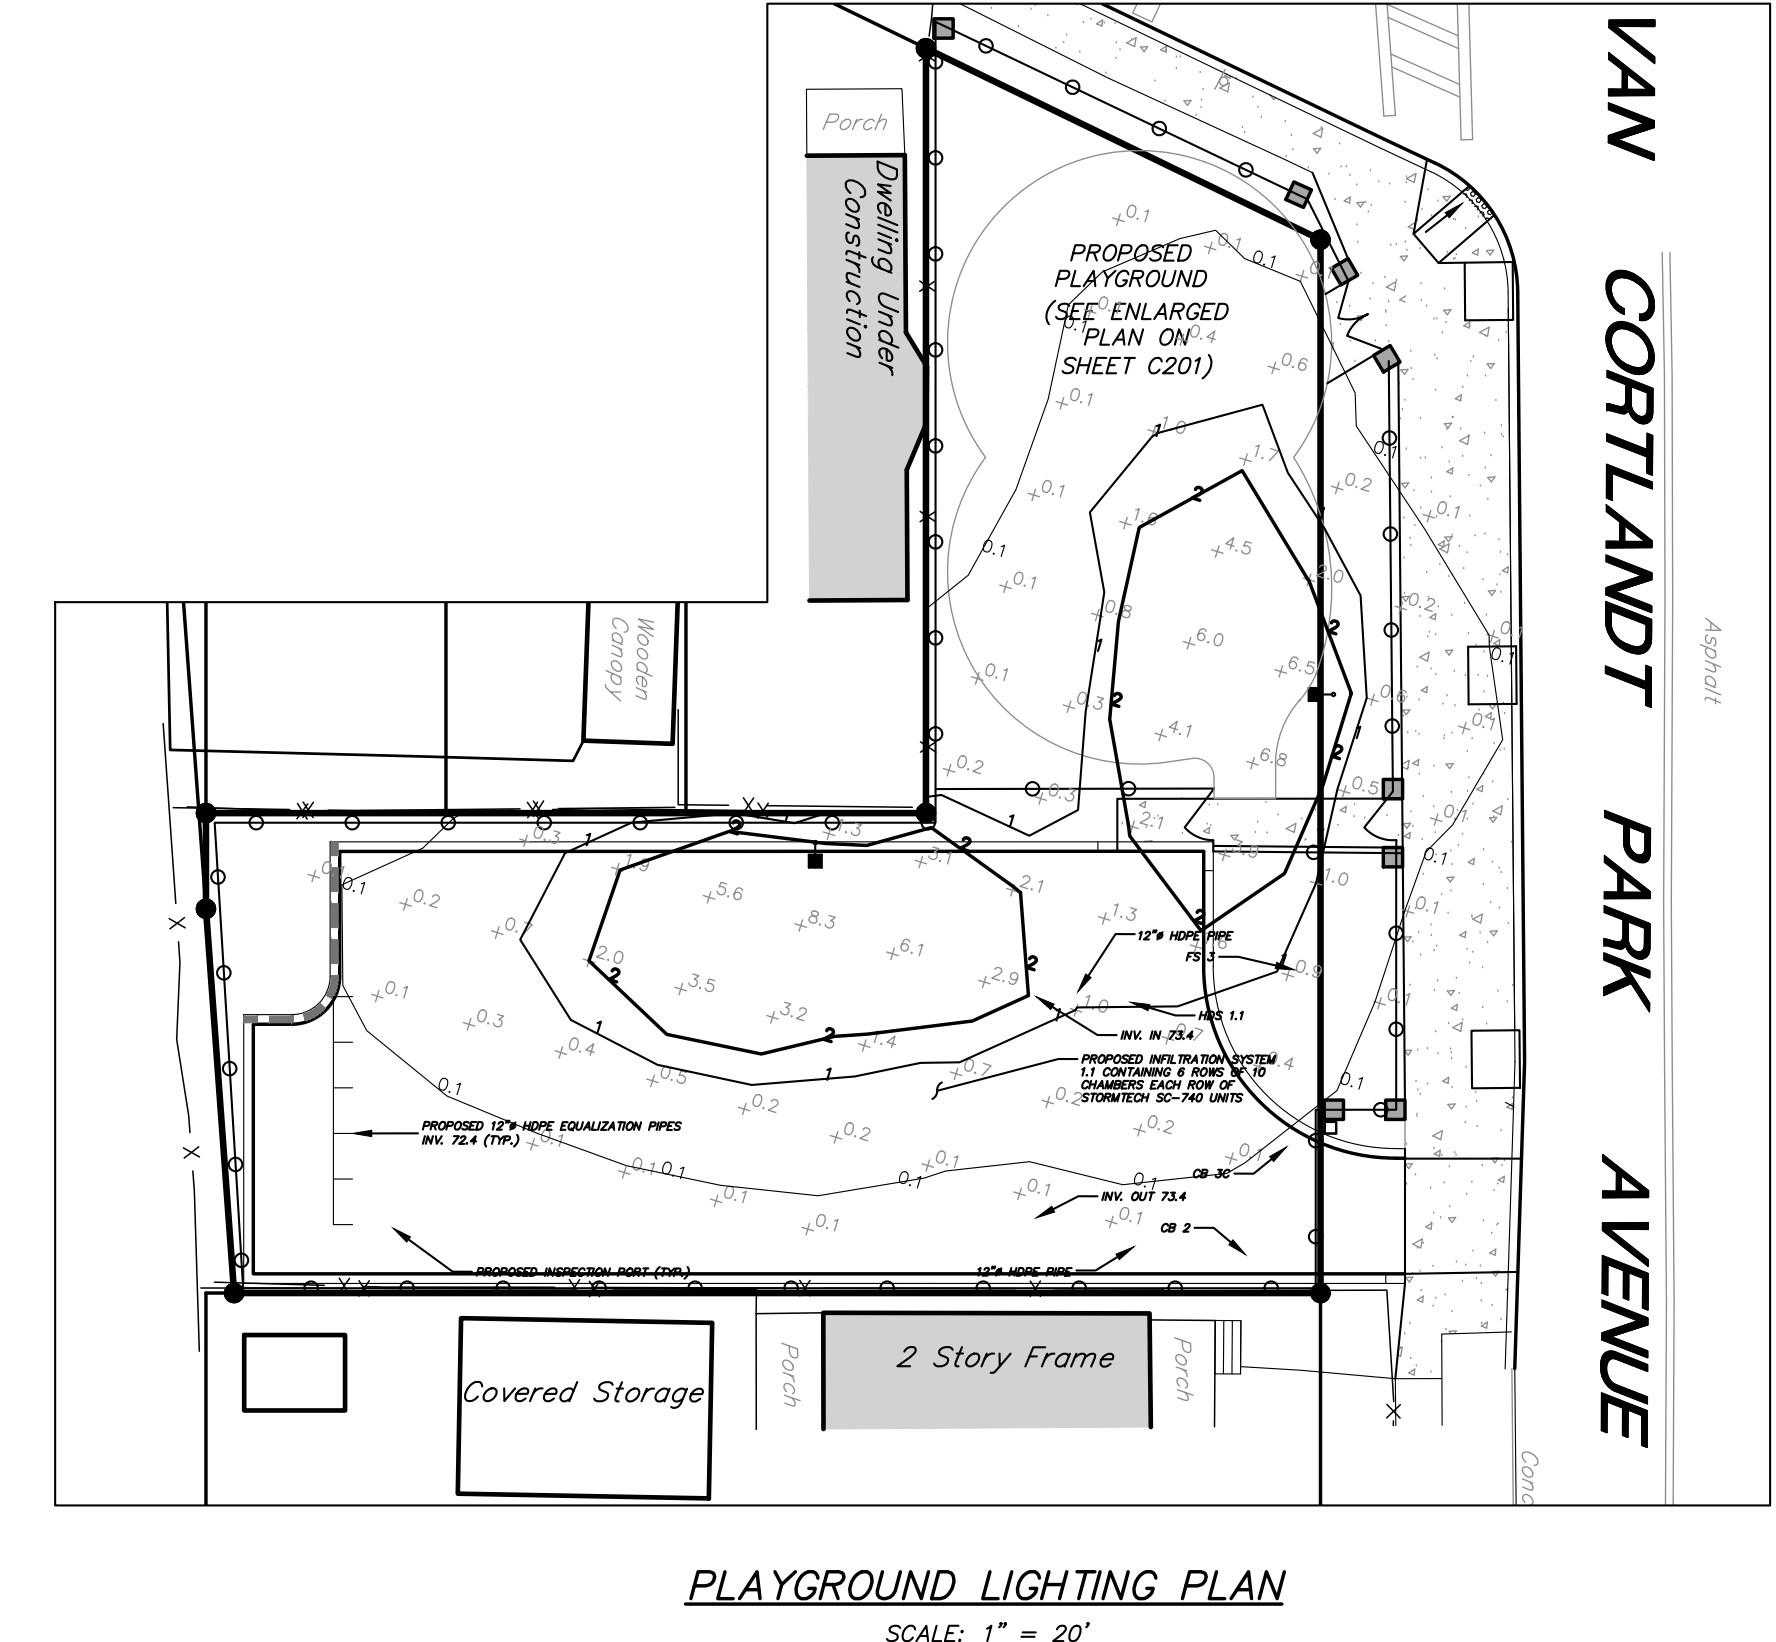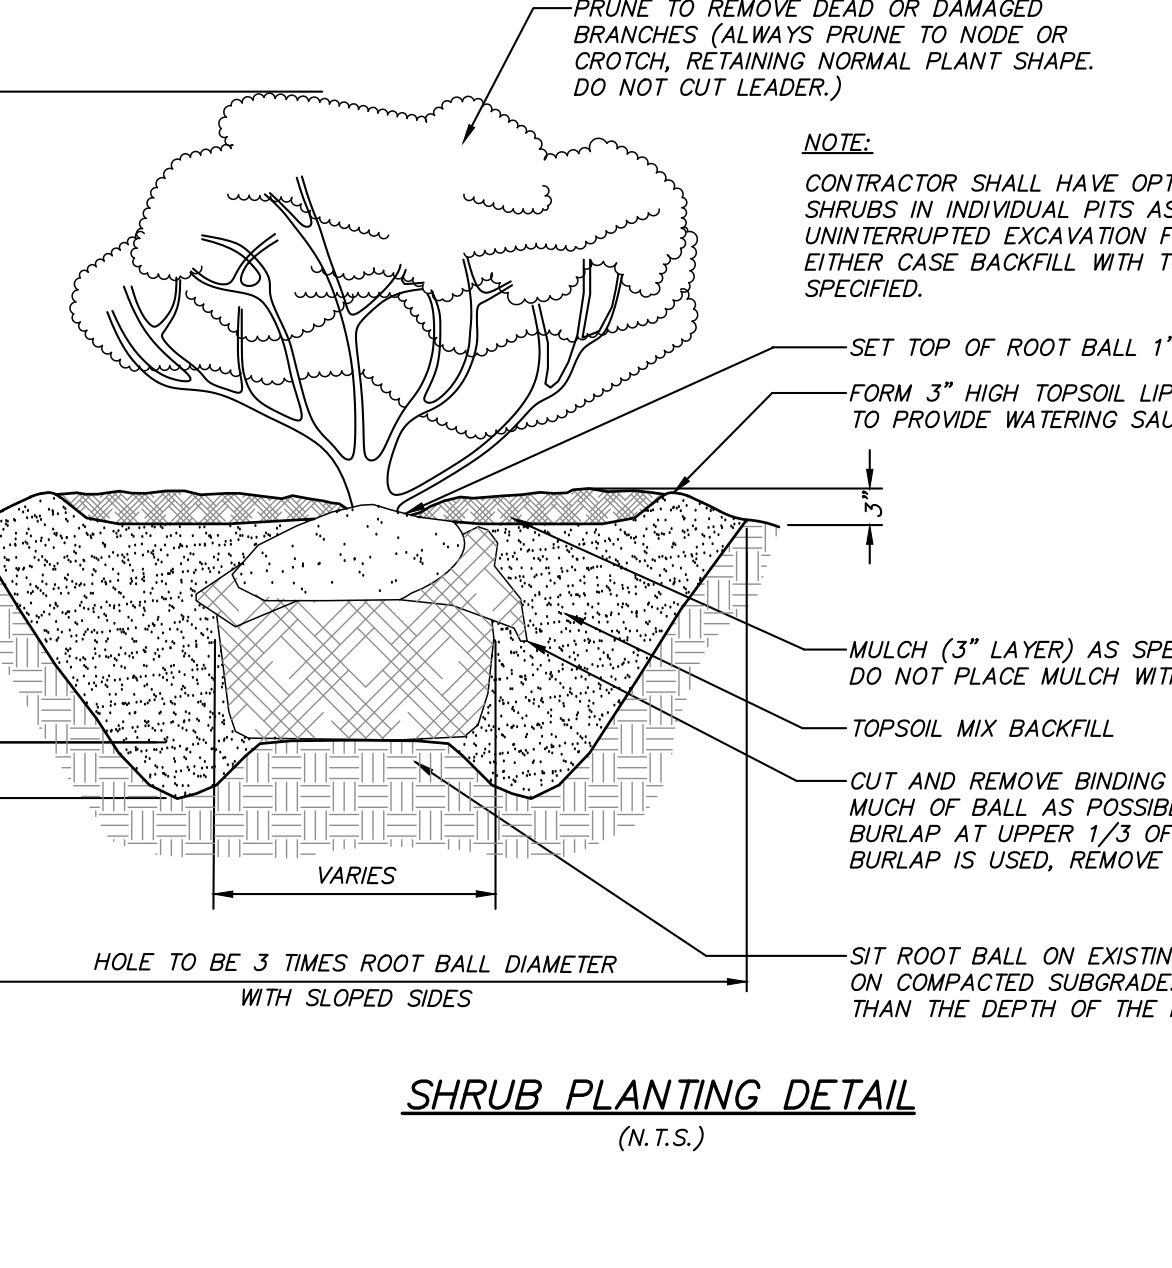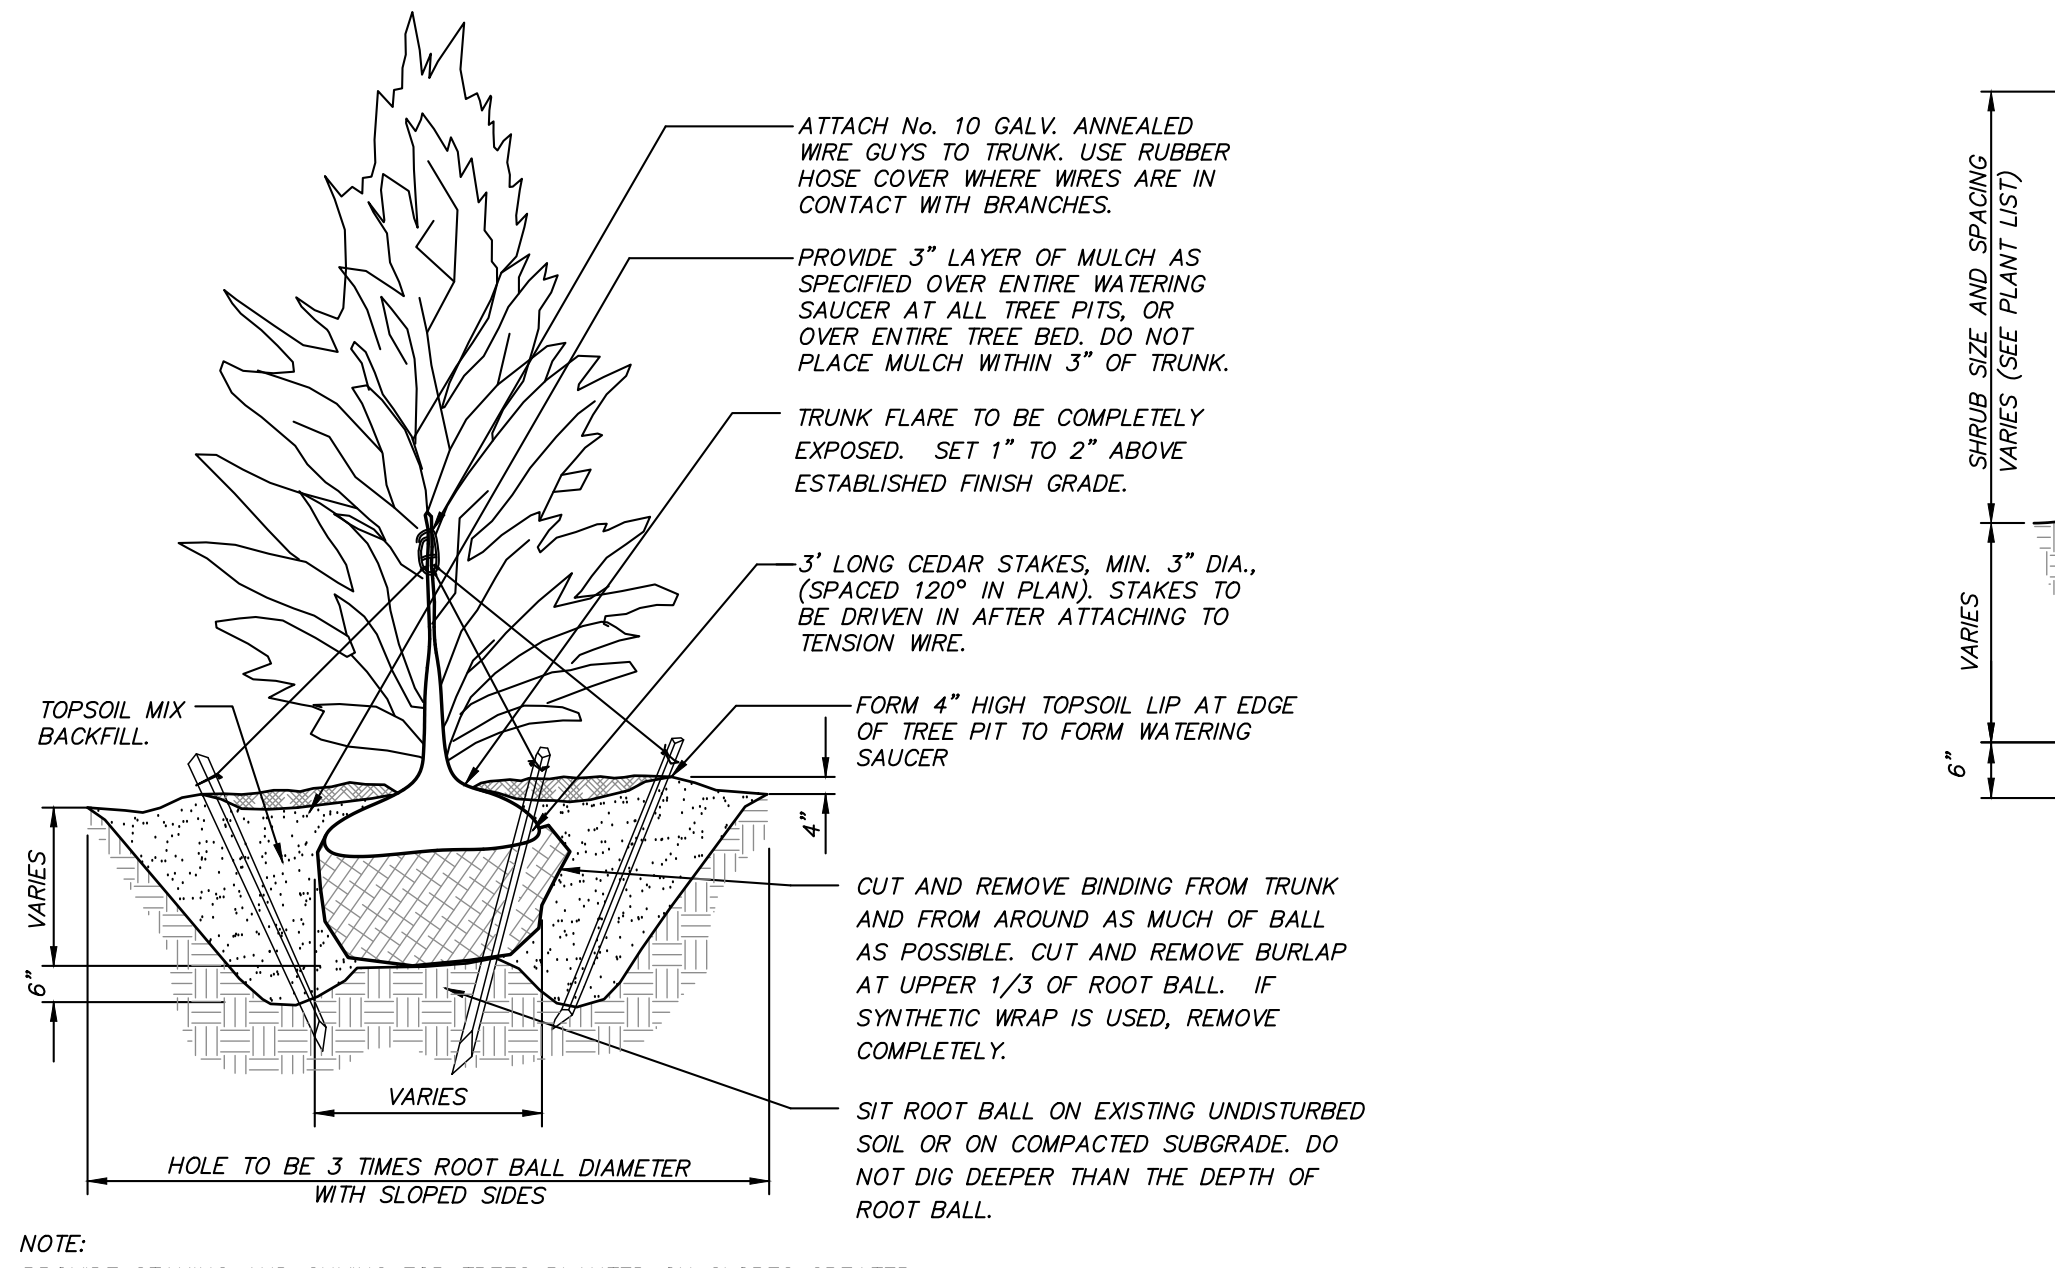

**NOTE:** ALL DIM. DIMENSIONS ARRANGEMENTS AND PLANS INDICATED OR REPRESENTED BY THIS DRAWING ARE OWNED BY AND ARE THE PROPERTY OF KGD ARCHITECTS, PC. NO PART OF THIS DRAWING IS TO BE REPRODUCED, COPIED, OR TRANSMITTED IN ANY FORM OR BY ANY MEANS, ELECTRONIC OR MECHANICAL, INCLUDING PHOTOCOPYING, RECORDING, OR BY ANY INFORMATION STORAGE AND RETRIEVAL SYSTEM, WITHOUT THE WRITTEN PERMISSION OF KGD ARCHITECTS, PC. ANY UNAUTHORIZED REPRODUCTION OR TRANSMISSION OF THIS DRAWING SHALL BE AT THE USER'S SOLE RISK AND WITHOUT LIABILITY TO KGD ARCHITECTS, PC. FOR ALL DIMENSIONS AND CONDITIONS ON THE JOB AND THE OFFICE MUST BE NOTICED BY ANY VARIATIONS FROM DIMENSIONS AND CONDITIONS SHOWN BY THESE DRAWINGS. SHOP DETAILS MUST BE SUBMITTED TO THIS OFFICE FOR APPROVAL BEFORE PROCEEDING WITH FABRICATION. LEGAL NOTICE: ALTERATIONS BY ANY PERSON IN ANY WAY OF ANY ITEM COPIED ON THIS DOCUMENT, UNLESS ACTING UNDER THE DIRECTION OF THE LICENSED ARCHITECT WHOSE PROFESSIONAL SEAL IS AFFIXED HERETO, IS A VIOLATION OF TITLE 16, SECTION 1703 OF NEW YORK STATE LAW. © COPYRIGHT KAYEYR, GARMENT & DAVENSON, PC. ALL RIGHTS RESERVED.



No.	Date	Issue
11/01/2021	ISSUE FOR BID	
08/24/2021	NYS ED ADDENDUM 1	
07/14/2021	CONST. DOCS - FOR NYSED	
12/15/2020	DESIGN DEVELOPMENT	
08/31/2020	SCHEMATIC DESIGN	

Sheet Title: **DETAILS**

Job No.	Date
2018-1071	8/30/2020

Scale:	Drawn / Checked
AS SHOWN	MEU/AT

Sheet No. **C402**